

Area Schedule (Rentable)		
Level	Name	Area
01-Base Level	Area	2594 SF
01-Base Level	Area	791 SF
01-Base Level	Area	1528 SF
01-Ground Level	Area	191 SF
01-Ground Level	Area	4228 SF
02-Level 2	Area	4239 SF
02-Level 2	Area	162 SF
03-Roof Level	Area	1574 SF
04-Top Roof Level 5	Area	1573 SF
03-Roof Level	Area	3022 SF

**COLOR COMPANY**  
www.mollyglidar.com

Consultant: INC ENGINEERING  
Address: 333 West state street  
Phone: 808 555 6509  
Fax: 1 808 555 6509  
e-mail: colorcompany@gmail.com

No.	Description	Date
1	House WEEK 5	09/18/20
2	House Week #7	09/20/20

House for week #5

**LEGAL DESCRIPTION**

E Legal Description: Rousakis Plaza  
Property Address: 143 West River Street  
Savannah, GA 31401

**SCOPE OF WORK**

DESIGN OF A RESIDENTIAL HOME ON A SLOPED LAND BY THE WATER, FOR A PRIVATE ARTIST.

**PROJECT TEAMS**

**ENGINEERING FIRM**

Hughs Engineering Consulting  
4208 Six Forks Road  
Suite 1000  
Raleigh, NC 27609 US  
+19198254845

**ARCHITECTURAL FIRM**

Molly Rae Architecture  
225 Bellefield Ave  
Suite 1000  
Cleveland, OH 43081 US  
+12169703273

Yiana Tjotjos  
Assignment #13  
Cover Sheet

Project number	Assignment #13
Date	Issue Date
Drawn by	Molly Glidar
Checked by	Prof. Wacta

A000

Scale 1" = 30'-0"

1 2

A

**PROJECT SURVEY**



Property Address: 143 W. River Street  
Savannah, GA 31402

**ZONE AND COMPLIANCE**

C

Estimated Zoning:  
D-W- Downtown Waterfront  
Calculated Acreage:  
2.93  
Local Historic District:  
Savannah Historic District  
Aldermanic District: SAV 1  
County Commision District: 3

D

**FLOOD ZONE AND COMPLIANCE**

E

Estimated Floodzone: AE

1 2

**SYMBOLS AND LEGENDS**

- Room name  
150 SF
- Area Tag
- Callout Head
- Center Line
- Door Tag
- Spot Elevation-Crosshair
- Section Head-Open
- Level Head- Circle
- Revision Tag
- North Arrow
- Grid Head- Circle
- Elevation Mark
- Room Tag with Area
- Span Direction
- Window Tag
- Structural Framing Tag
- Wall Tag
- 
- 
- 
- 

3 4

5 6

**SHEET LIST**

 
Sheet List	
Sheet Number	Sheet Name
A001	PROJECT DATA
A101	Basement Plan
A102	Ground Floor
A103	Second Level
A104	Roof Level 4
A105	Top Roof Level 5
A201	North Elevation
A202	East Elevation
A203	South Elevation
A204	West Elevation
A801	3D Exterior
A802	3D Exterior 2
A000	Cover Sheet
A301	Section
A302	Section
A303	Section
A002	Notes
A110	Basement Color
A111	Ground Floor Color
A112	Level Two Color
A205	Interior Elevation-KITCHEN
A206	Interior Elevation-TV/DEN
A113	Poche Plans
A114	Poche Plans
A115	Floor Plan Base Finish
A116	Floor Plan Ground Finish
A117	Floor Plan Level 2 Finish
A401	Enlarge Plans Basement
A402	Enlarge Floor Plans Ground Level
A403	Enlarge Floor Plans Level 2
A404	Enlarge Transverse Section
A405	Enlarges Longitude Section
A901	Exploded Axon
A902	Section and Axon1
A903	Section and Axon
A803	Interior Camera View Base Level
A804	Camera View Ground Level
A805	Interior Camera View Level 2
A804	Light Fixture Schedule
A501	Ceiling Plan Basement
A502	Ceiling Plan Ground Level
A503	Ceiling Plan Level 2

5 6



www.mollygildar.com

Consultant: INC ENGINEERING  
Address: 333 West state street  
Phone: 808 555 6509  
Fax: 1 808 555 6509  
e-mail: colorcompany@gmail.com



No.	Description	Date
1	House WEEK 5	09/18/20



House for week #5

Yiana Tjotjos  
Assignment #13  
PROJECT DATA

Project number: Assignment #13  
Date: Issue Date  
Drawn by: Molly Gildar  
Checked by: Prof. Wacta

**A001**

Scale: 3/16" = 1'-0"

1

2

3

4

5

6

GENERAL NOTES

A

1. INFORMATION CONTAINED ON THESE DRAWINGS IS PROVIDED FOR THE GENERAL CONTRACTOR IN ORDER TO EXECUTE THE WORK. EVERY ATTEMPT HAS BEEN MADE TO PROVIDE COMPLETE AND ACCURATE REPRESENTATIONS OF ALL CONDITIONS.

2. FOR DIMENSIONS NOT SHOWN OR IN QUESTION, THE CONTRACTOR SHALL REQUEST CLARIFICATION FROM THE ARCHITECT BEFORE ACTING.

B

3. THE CONTRACTOR SHALL RECORD ALL CHANGES AND DEVIATIONS FROM THE DRAWINGS IN THIS "AS BUILT" SET, WHICH SHALL BE UPDATED AT LEAST EVERY OTHER WEEK AT THE CLOSE OF THE JOB.

4. THE CONTRACTOR SHALL PROVIDE ONE COMPLETE SET OF ALL "AS BUILT" INFORMATION TO THE ARCHITECT IN CLEAR AND LEGIBLE FORMAT.

C

5. ALL CONSTRUCTION, ALTERATIONS, MOVEMENT, ENLARGEMENT, REPLACEMENT AND REPAIR SHALL COMPLY WITH ALL CURRENT EDITIONS AND REVISIONS OF THE 2006 INTERNATIONAL BUILDING CODE.

CONSTRUCTION NOTES

D

1. ALL BUILDING SETBACKS ARE TO CONFORM TO LOCAL ZONING ORDINANCES.

2. THIS PROPERTY IS SUBJECT TO ANY AND ALL EASEMENTS, COVENANTS, OR RESTRICTIONS EITHER RECORDED OR UNRECORDED.

E

3. ALL INTERIOR AND EXTERIOR WORK SHALL COMPLY WITH ALL APPLICABLE BUILDING CODES AND LOCAL ORDINANCES.

4. THE RENOVATION DOES NOT INTERFERE WITH ADJACENT OR NEARBY PROPERTIES.

1


2

3

4

5

6

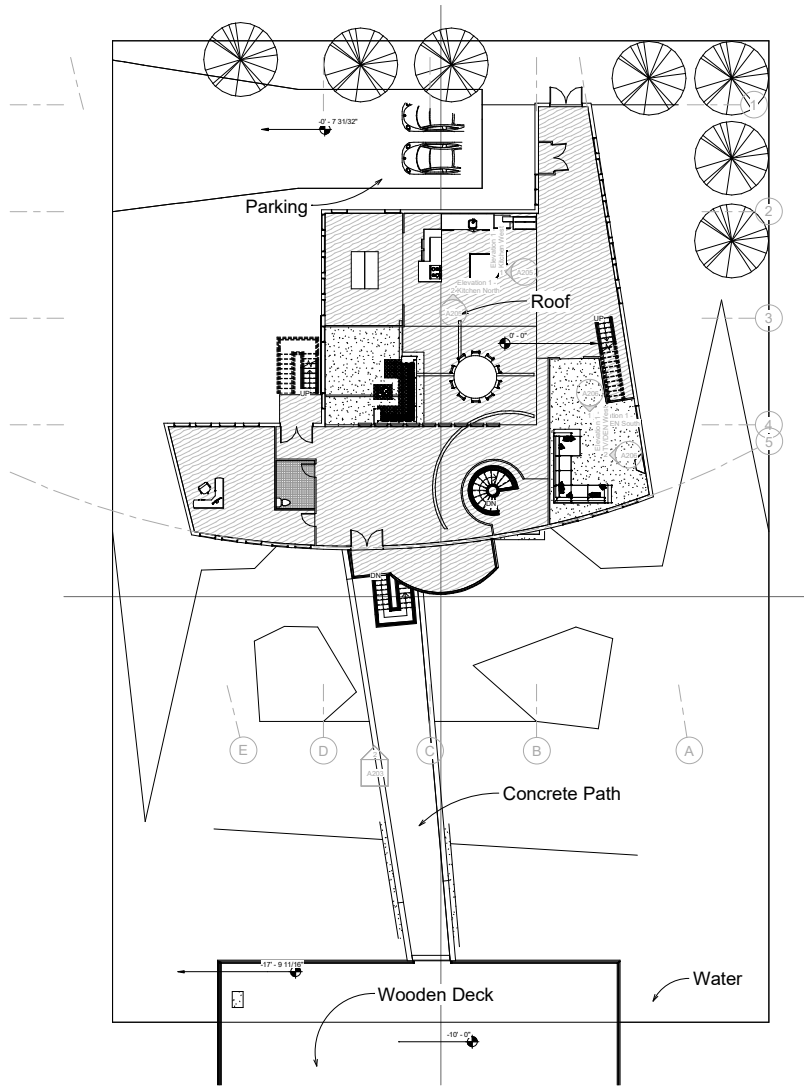

A

B

C

D

E



www.mollygildar.com

Consultant: NYC ENGINEERING  
 Address: 333 West state street  
 Phone: 808 555 6509  
 Fax: 1 808 555 6509  
 e-mail: colorcompany@gmail.com


No.	Description	Date
1	House WEEK 5	09/18/20

House for week #5


Yiana Tjotjos  
 Assignment #13  
 Notes

Project number	Assignment #13
Date	Issue Date
Drawn by	Author
Checked by	Checker
<b>A002</b>	
Scale	1" = 10'-0"

4/17/2020 9:45:06 AM

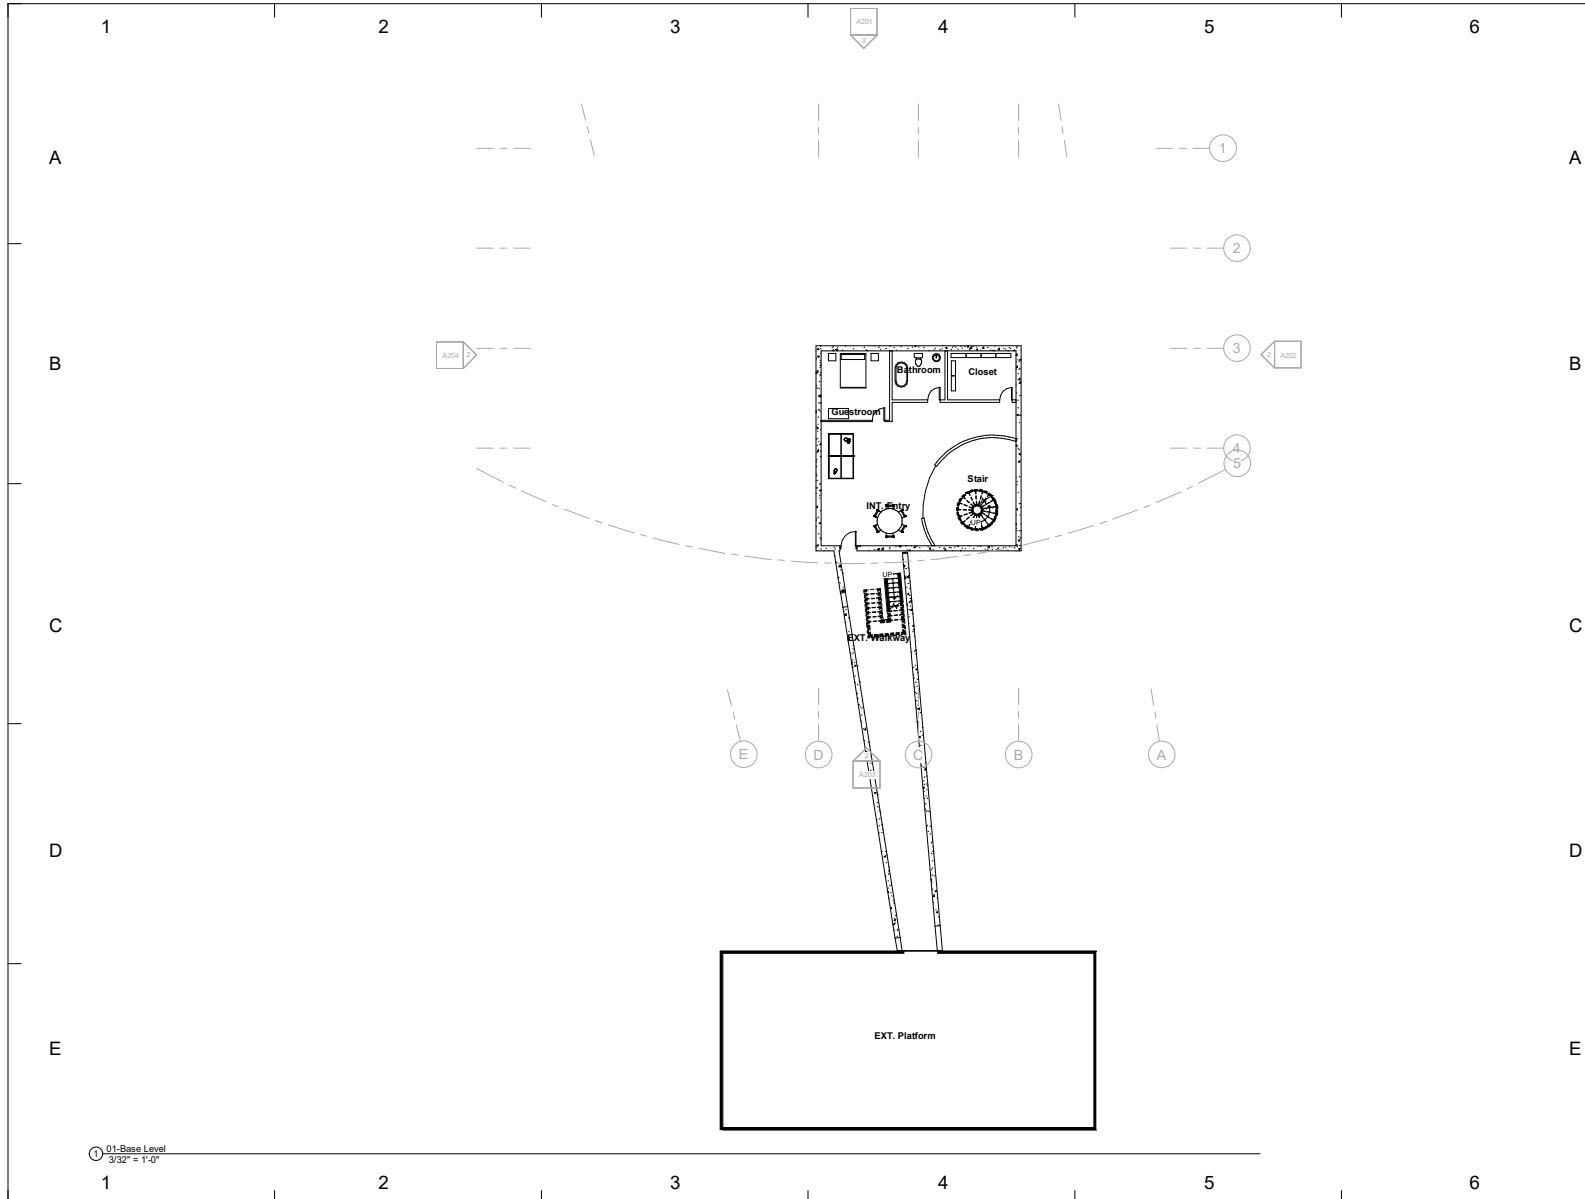

① 01-Basis Level  
3/32" = 1'-0"




**COLOR COMPANY**

 www.mollygildar.com

---

Consultant: INC ENGINEERING  
 Address: 333 West state street  
 Address: 333 West state street  
 Phone: 808 555 6509  
 Fax: 1 808 555 6509  
 e-mail: colorcompany@gmail.com

---



---

No.	Description	Date
1	House WEEK 5	09/18/20

---

House for week #5

---

**Yiana Tjotjos**  
 Assignment #13  
 Basement Plan

---


Project number	Assignment #13
Date	Issue Date
Drawn by	Author
Checked by	Checker

A101

---


Scale: 3/32" = 1'-0"

4/17/2020 04:45 PM

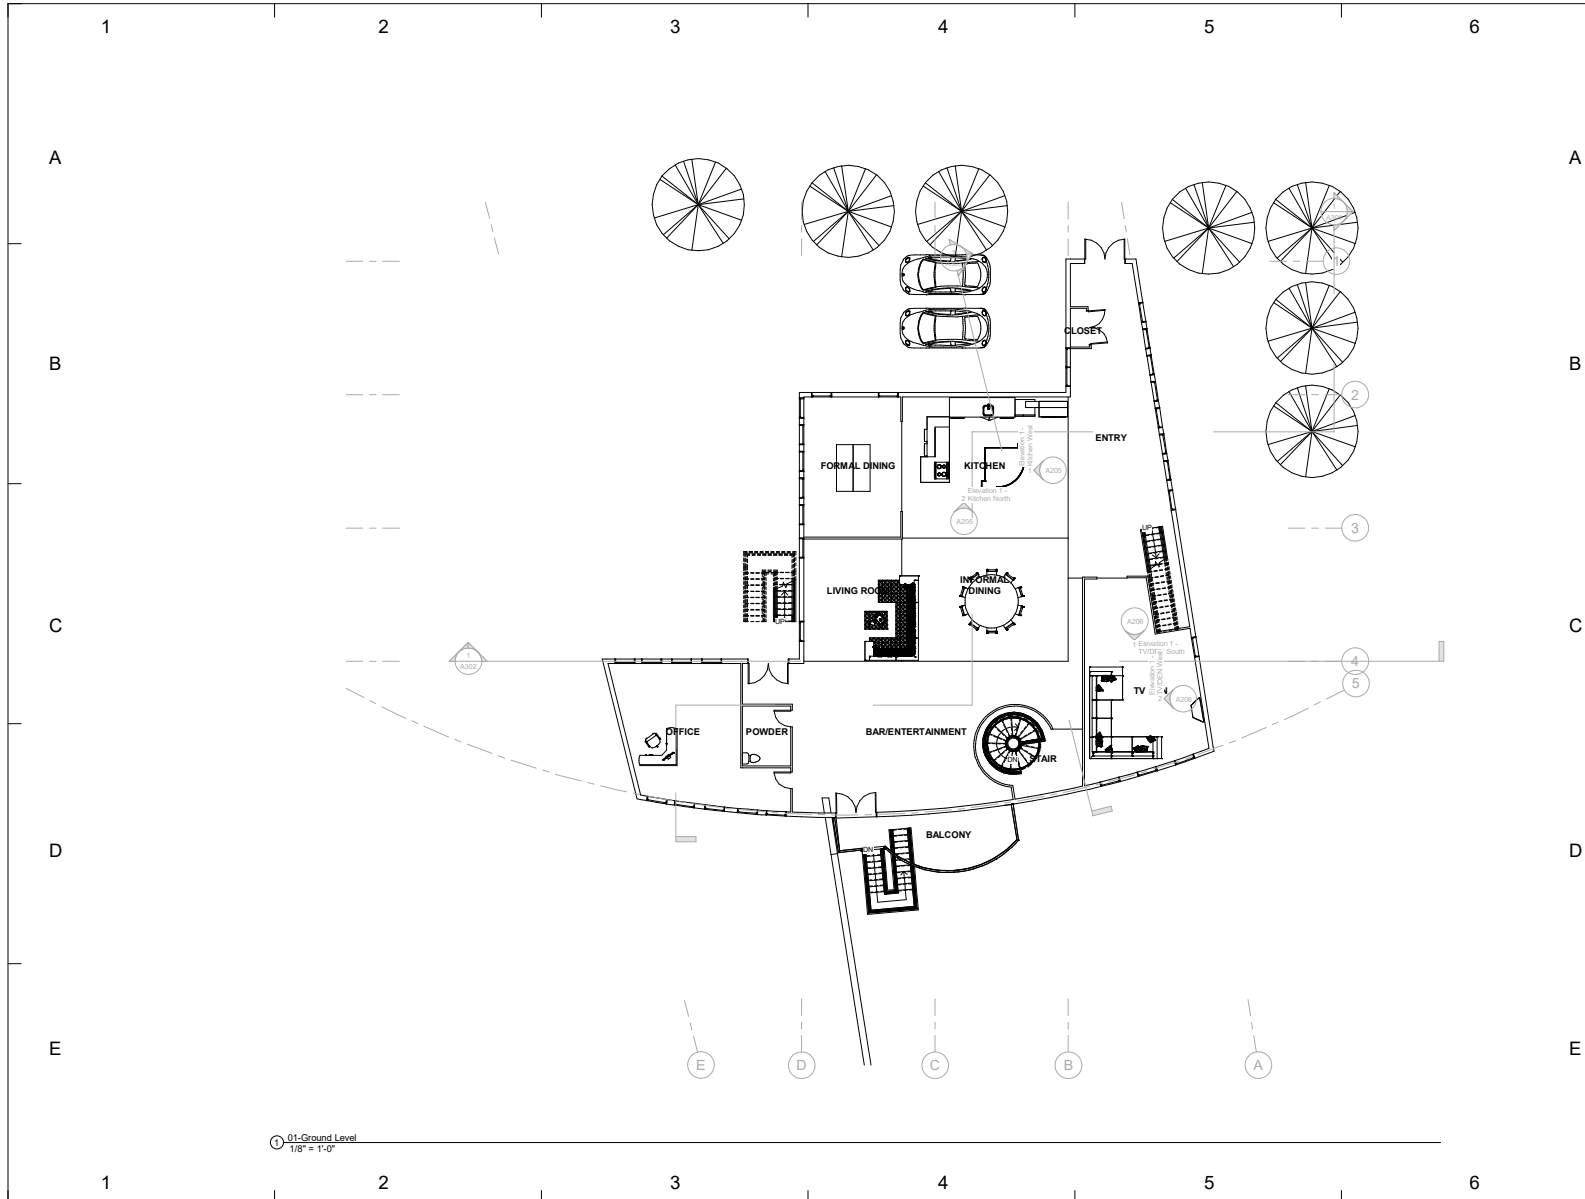

www.mollygildar.com

 Consultant: INC ENGINEERING  
 Address: 333 West state street  
 Phone: 808 555 6509  
 Fax: 1 808 555 6509  
 e-mail: colorcompany@gmail.com




No.	Description	Date
1	House WEEK 5	09/18/20

House for week #5

Yiana Tjotjos  
 Assignment #13  
 Ground Floor

Project number	Assignment #13
Date	Issue Date
Drawn by	Author
Checked by	Prof. Wacta
<b>A102</b>	
Scale	1/8" = 1'-0"

4/17/2020 9:45:09 PM

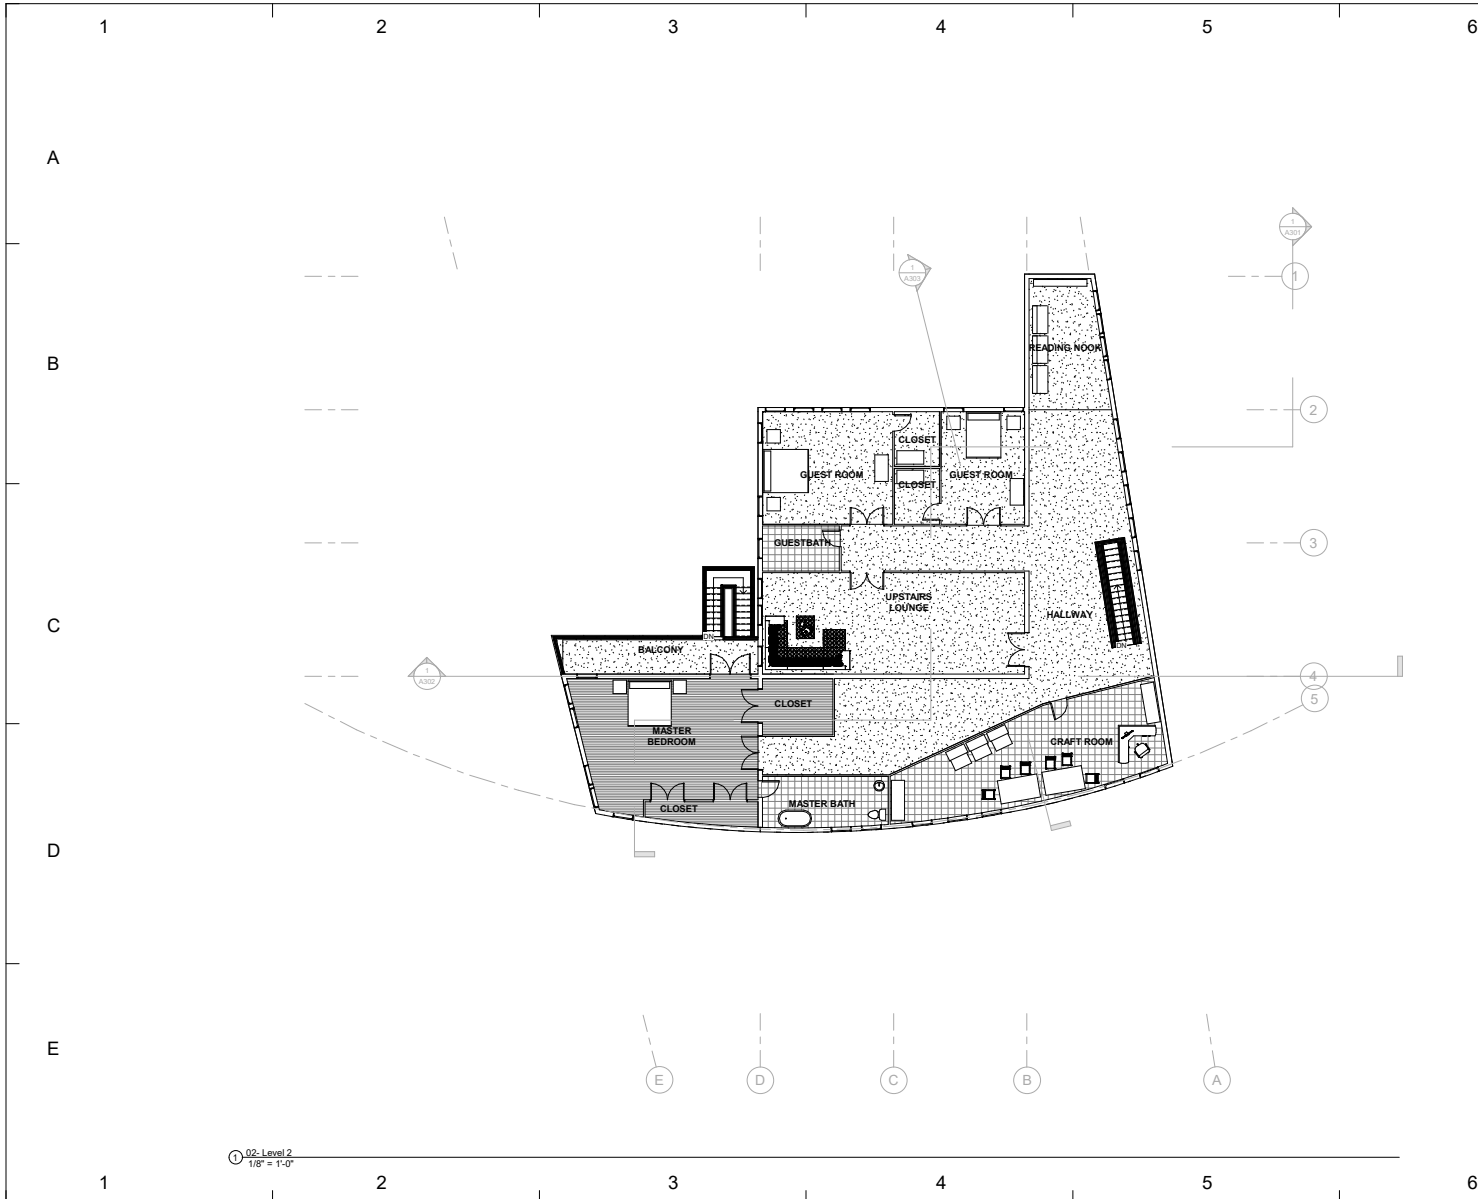

www.mollygildar.com

Consultant: INC ENGINEERING  
 Address: 333 West state street  
 Phone: 808 555 6509  
 Fax: 1 808 555 6509  
 e-mail: colorcompany@gmail.com




No.	Description	Date
1	House WEEK 5	09/18/20

House for week #5

Yiana Tjotjos  
 Assignment #13  
 Second Level

Project number	Assignment #13
Date	Issue Date
Drawn by	Author
Checked by	Checker
<b>A103</b>	
Scale	1/8" = 1'-0"

4/17/2020 9:45:01 PM

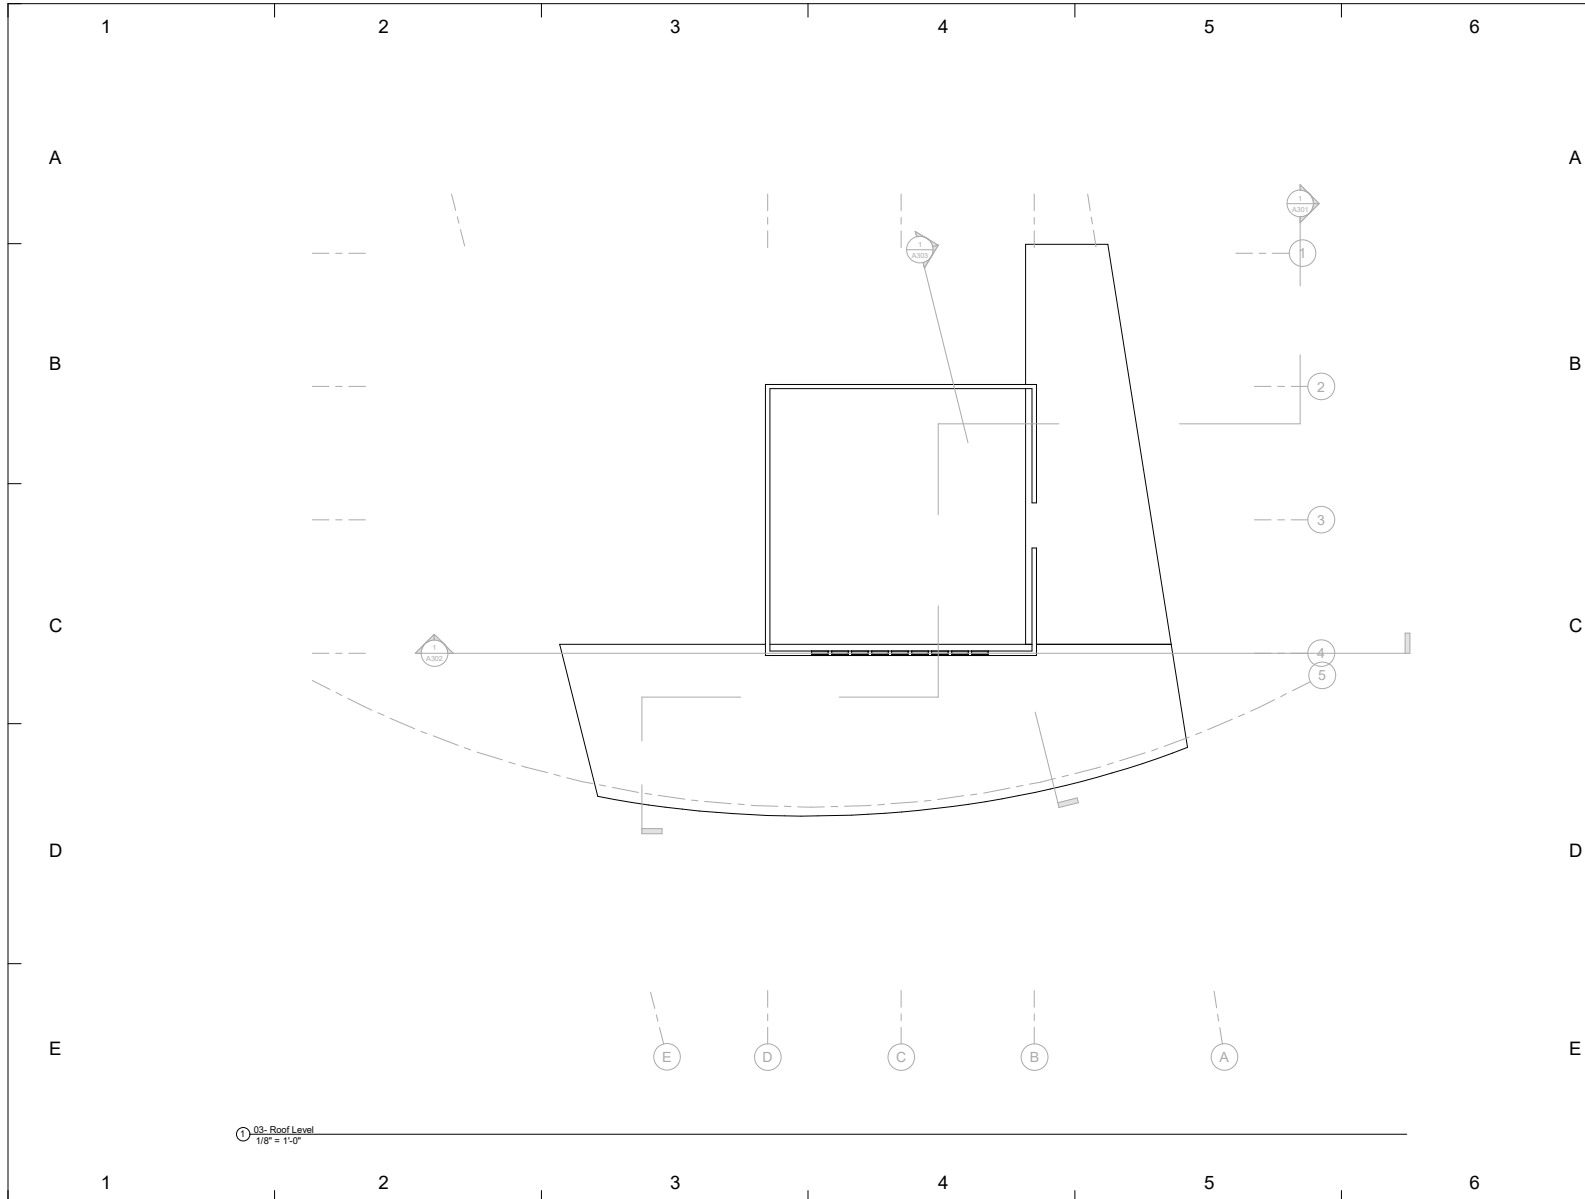

03- Roof Level  
1/8" = 1'-0"



www.mollygildar.com

Consultant: INC ENGINEERING  
Address: 333 West state street  
Phone: 808 555 6509  
Fax: 1 808 555 6509  
e-mail: colorcompany@gmail.com




No.	Description	Date
1	House WEEK 5	09/18/20

House for week #5

Yiana Tjotjos  
Assignment #13  
Roof Level 4

Project number	Assignment #13
Date	Issue Date
Drawn by	Author
Checked by	Checker
<b>A104</b>	
Scale	1/8" = 1'-0"

4/17/2020 9:45:03 PM

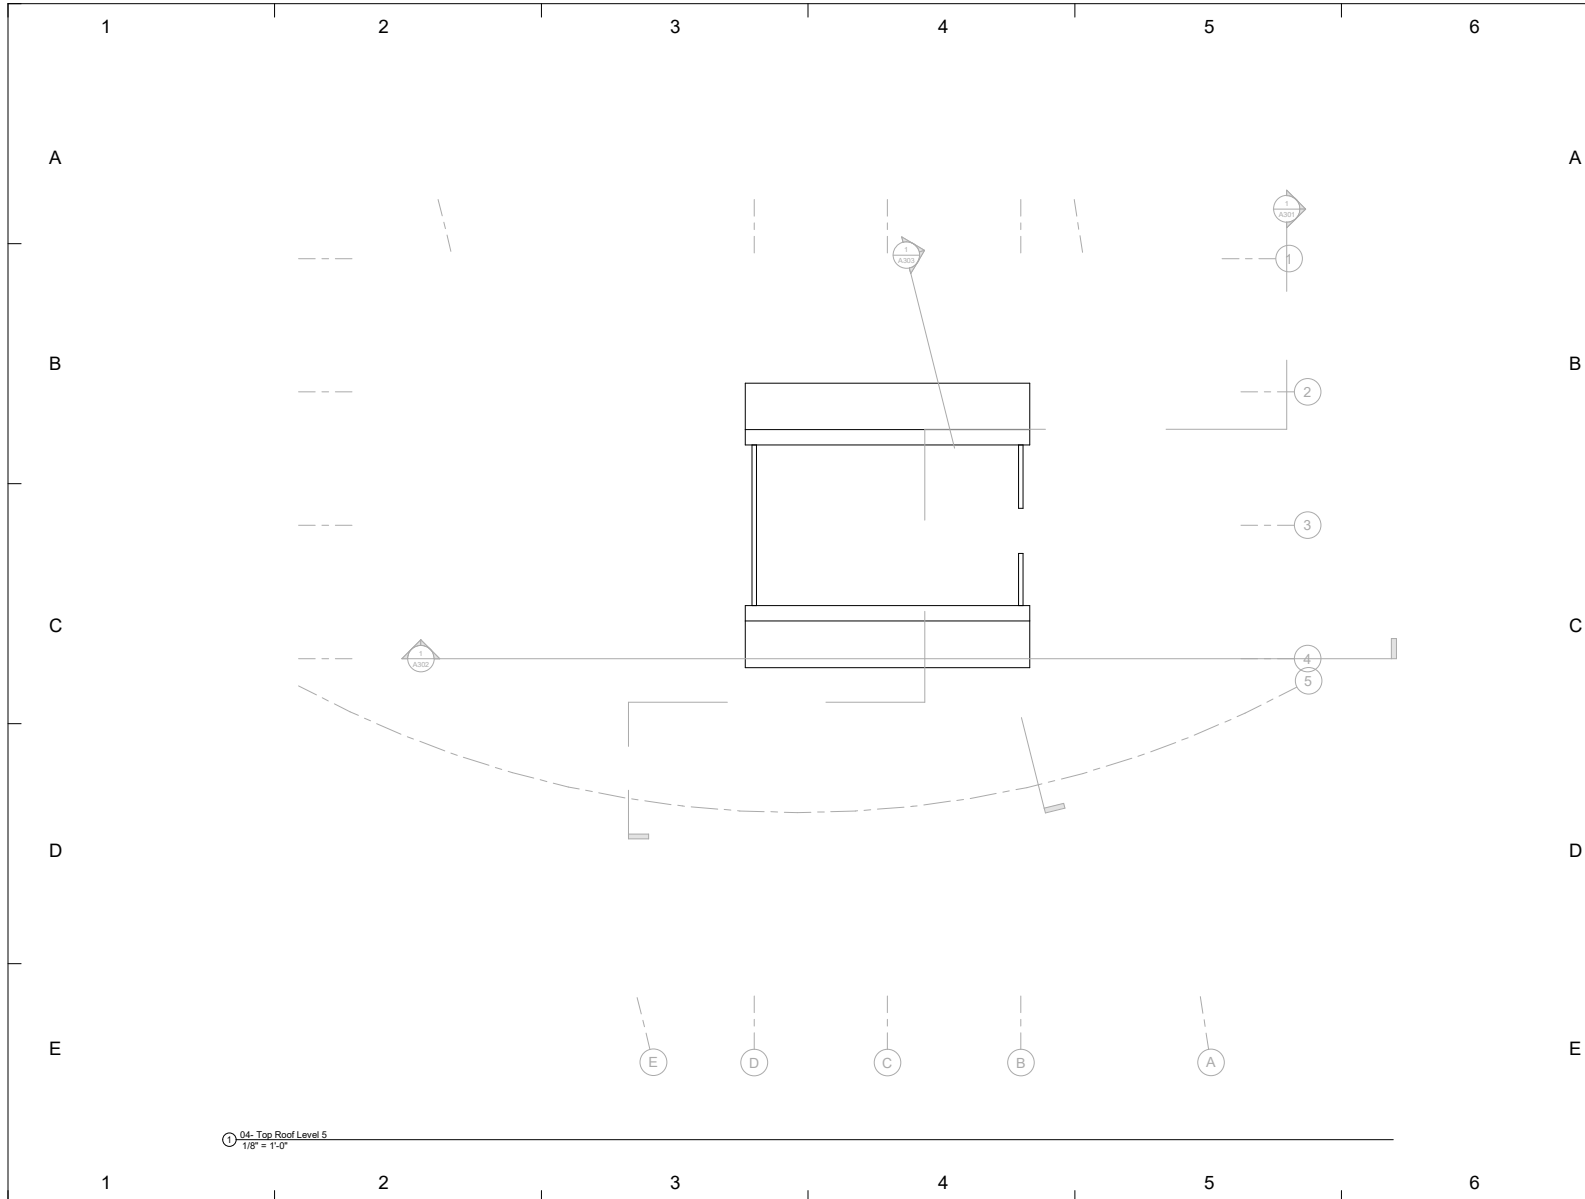

① 04- Top Roof Level 5  
1/8" = 1'-0"



www.mollygildar.com

Consultant: INC ENGINEERING  
Address: 333 West state street  
Phone: 808 555 6509  
Fax: 1 808 555 6509  
e-mail: colorcompany@gmail.com




No.	Description	Date
1	House WEEK 5	09/18/20

House for week #5

Yiana Tjotjos  
Assignment #13  
Top Roof Level 5

Project number	Assignment #13
Date	Issue Date
Drawn by	Author
Checked by	Checker
<b>A105</b>	
Scale	1/8" = 1'-0"



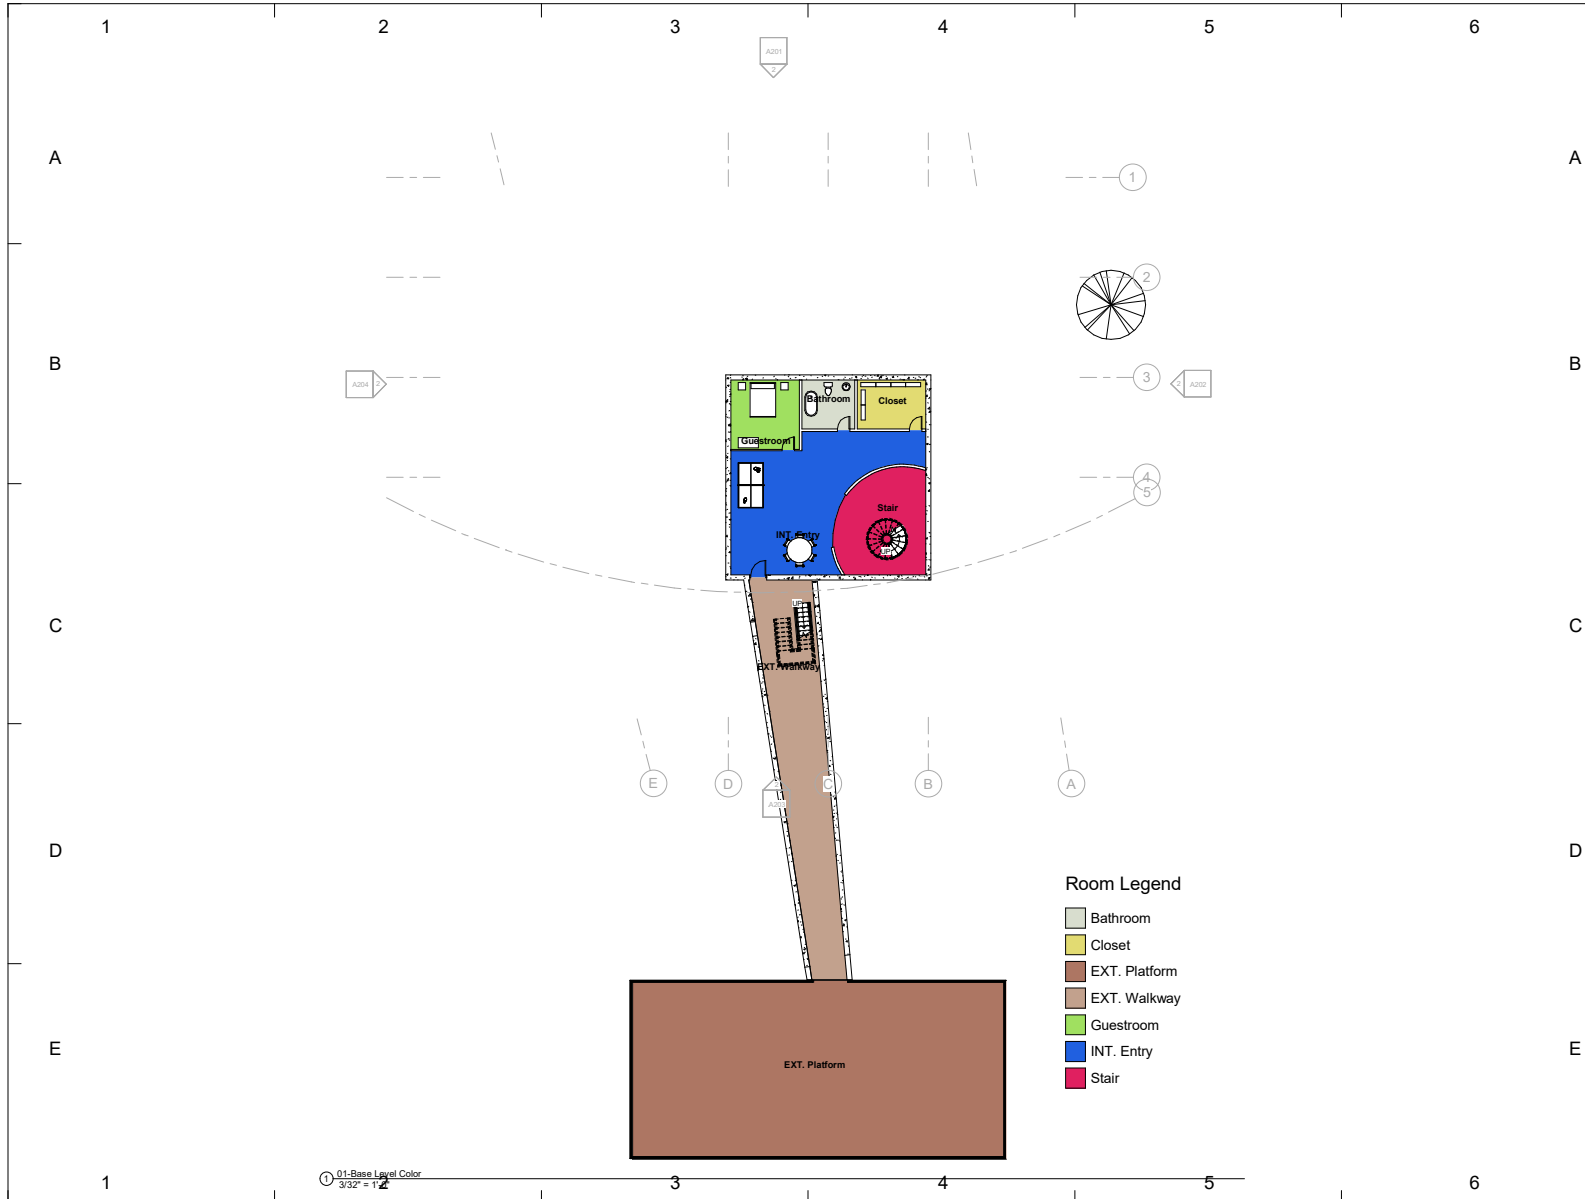


- Room Legend**
- Bathroom
  - Closet
  - EXT. Platform
  - EXT. Walkway
  - Guestroom
  - INT. Entry
  - Stair

01-Base Level Color  
3/32" = 1'-0"



www.mollygildar.com

 Consultant: INC ENGINEERING  
Address: 333 West state street  
Phone: 808 555 6509  
Fax: 1 808 555 6509  
e-mail: colorcompany@gmail.com



No.	Description	Date
1	House WEEK 5	09/18/20

House for week #5


**Yiana Tjotjos**  
**Assignment #13**  
**Basement Color**

Project number	Assignment #13
Date	Issue Date
Drawn by	Molly Gildar
Checked by	Prof. Wacta

**A110**

Scale 3/32" = 1'-0"

4/17/2020 9:45:04 AM

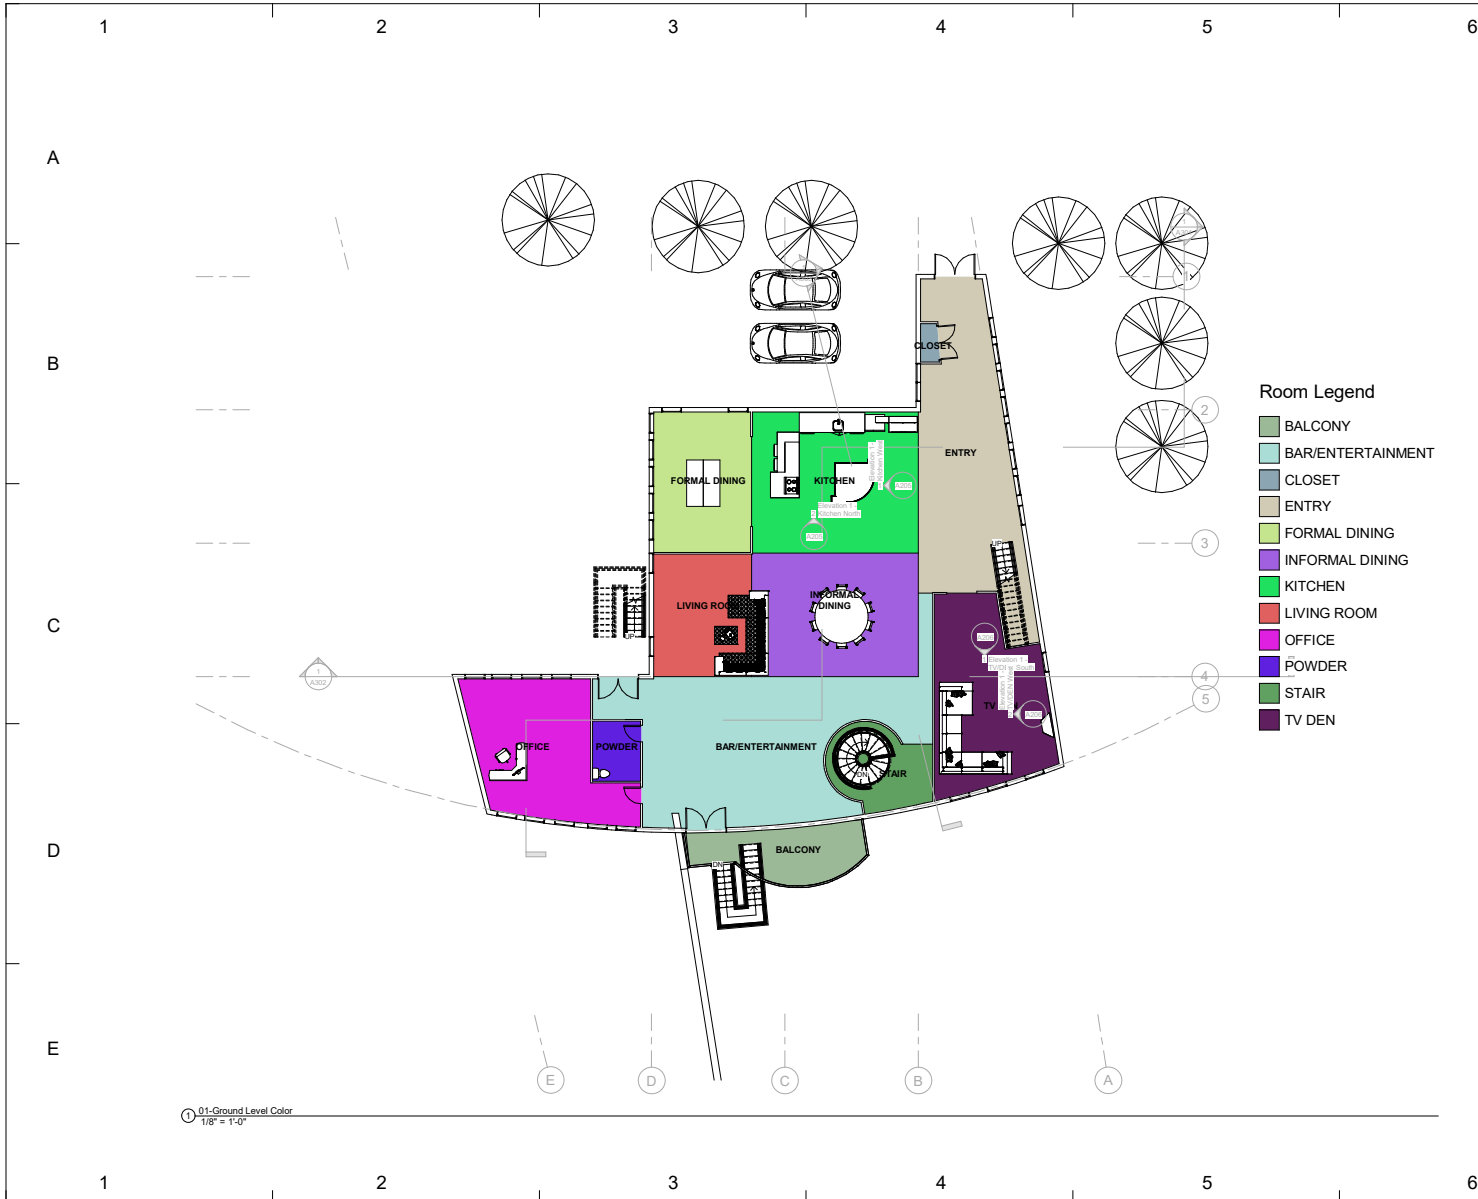


- Room Legend**
- BALCONY
  - BAR/ENTERTAINMENT
  - CLOSET
  - ENTRY
  - FORMAL DINING
  - INFORMAL DINING
  - KITCHEN
  - LIVING ROOM
  - OFFICE
  - POWDER
  - STAIR
  - TV DEN



www.mollyglidar.com

 Consultant: INC ENGINEERING  
 Address: 333 West state street  
 Phone: 808 555 6509  
 Fax: 1 808 555 6509  
 e-mail: colorcompany@gmail.com



No.	Description	Date
1	House WEEK 5	09/18/20

House for week #5


Yiana Tjoṭjos  
 Assignment #13  
 Ground Floor Color

Project number: Assignment #13  
 Date: Issue Date  
 Drawn by: Molly Glidar  
 Checked by: Prof. Wacta

**A111**

Scale: 1/8" = 1'-0"

4/17/2020 9:45:12 PM

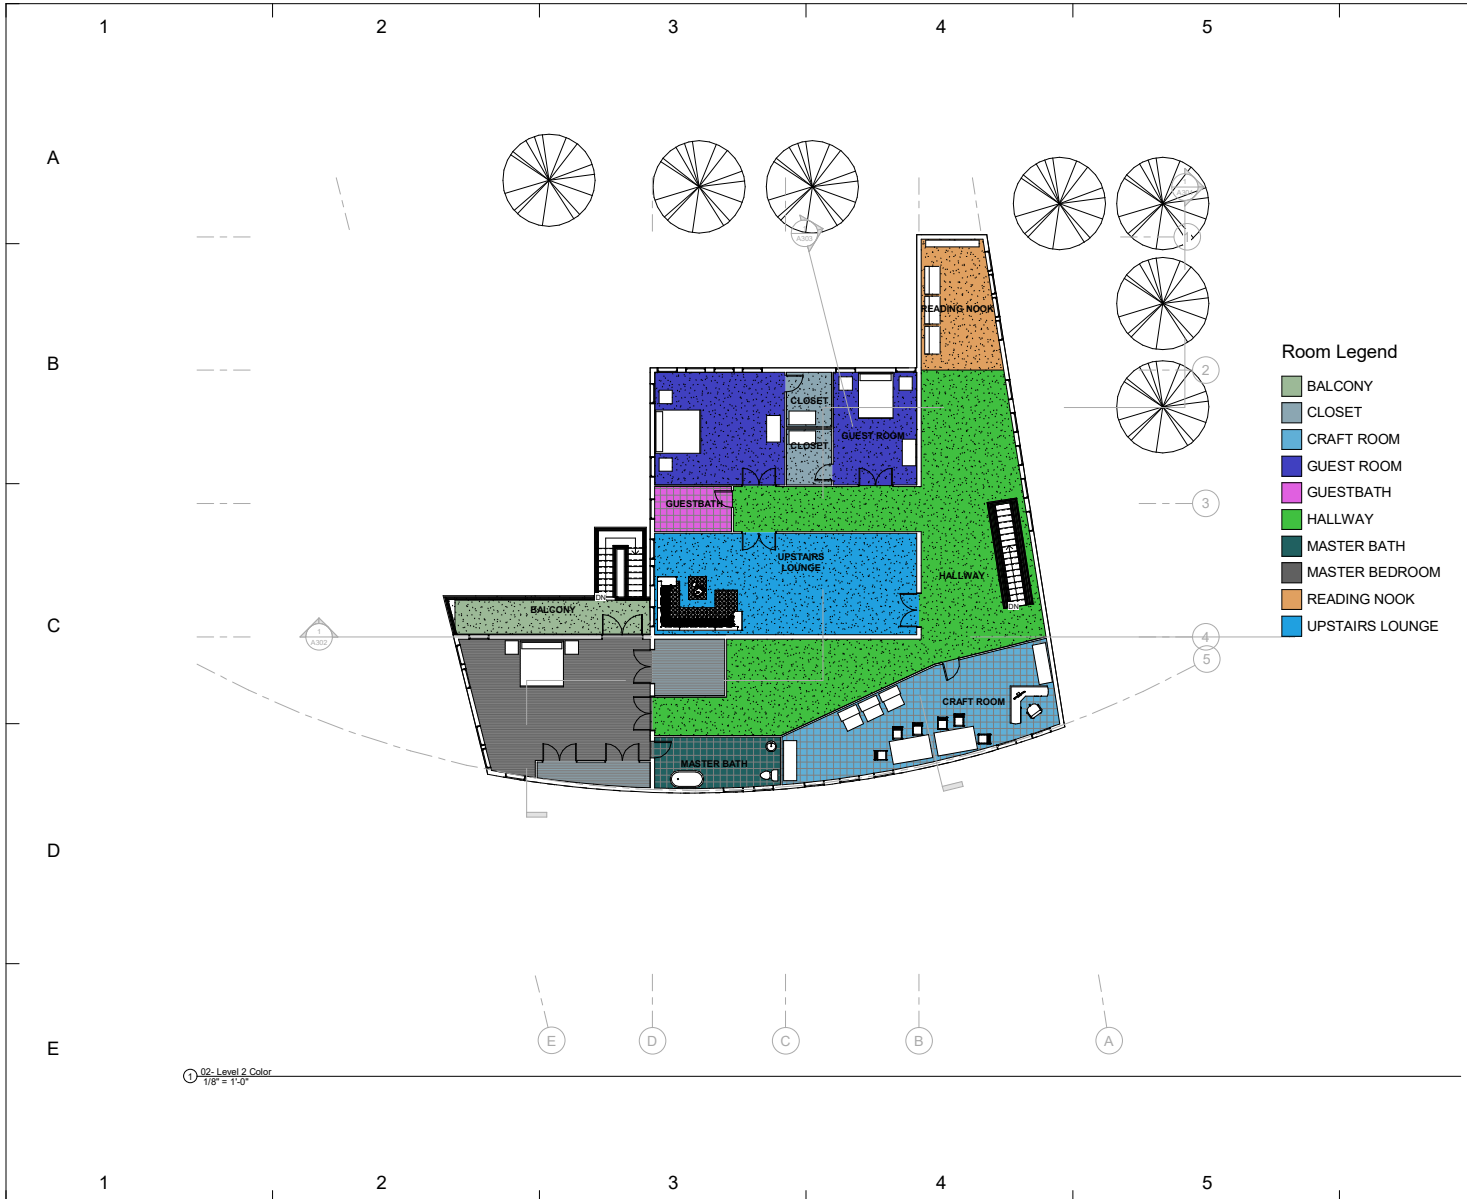


**Room Legend**

- BALCONY
- CLOSET
- CRAFT ROOM
- GUEST ROOM
- GUESTBATH
- HALLWAY
- MASTER BATH
- MASTER BEDROOM
- READING NOOK
- UPSTAIRS LOUNGE



www.mollygildar.com

Consultant: INC ENGINEERING  
 Address: 333 West state street  
 Phone: 808 555 6509  
 Fax: 1 808 555 6509  
 e-mail: colorcompany@gmail.com

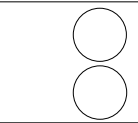

No.	Description	Date
1	House WEEK 5	09/18/20


House for week #5

**Yiana Tjotjos**  
**Assignment #13**  
**Level Two Color**

Project number: Assignment #13  
 Date: Issue Date  
 Drawn by: Molly Gildar  
 Checked by: Prof. Wacta


**A112**

Scale: 1/8" = 1'-0"

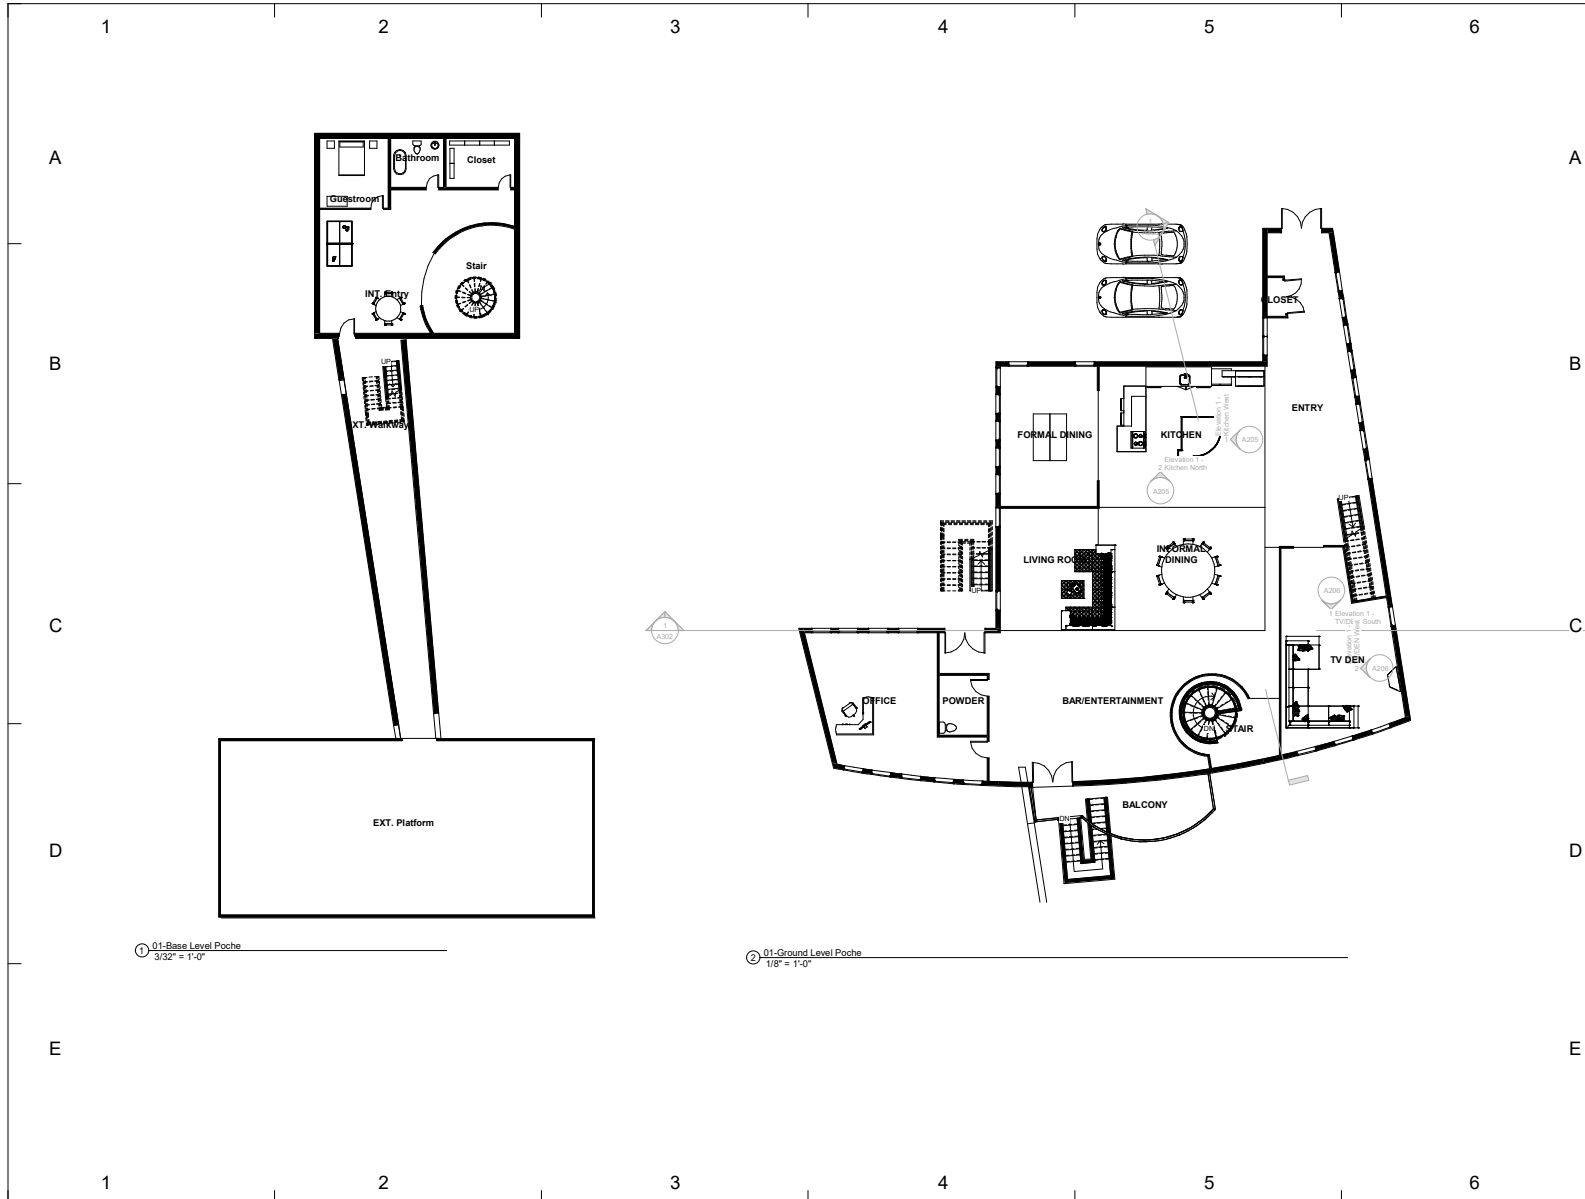

www.mollygildar.com

Consultant: INC ENGINEERING  
 Address: 333 West state street  
 Phone: 808 555 6509  
 Fax: 1 808 555 6509  
 e-mail: colorcompany@gmail.com

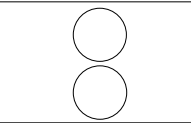

No.	Description	Date
1	House WEEK 5	09/18/20


House for week #5

Yiana Tjoṭjos  
 Assignment #13  
 Poche Plans

Project number: Assignment #13  
 Date: Issue Date  
 Drawn by: Molly Gildar  
 Checked by: Prof. Wacta

**A113**

Scale: As indicated

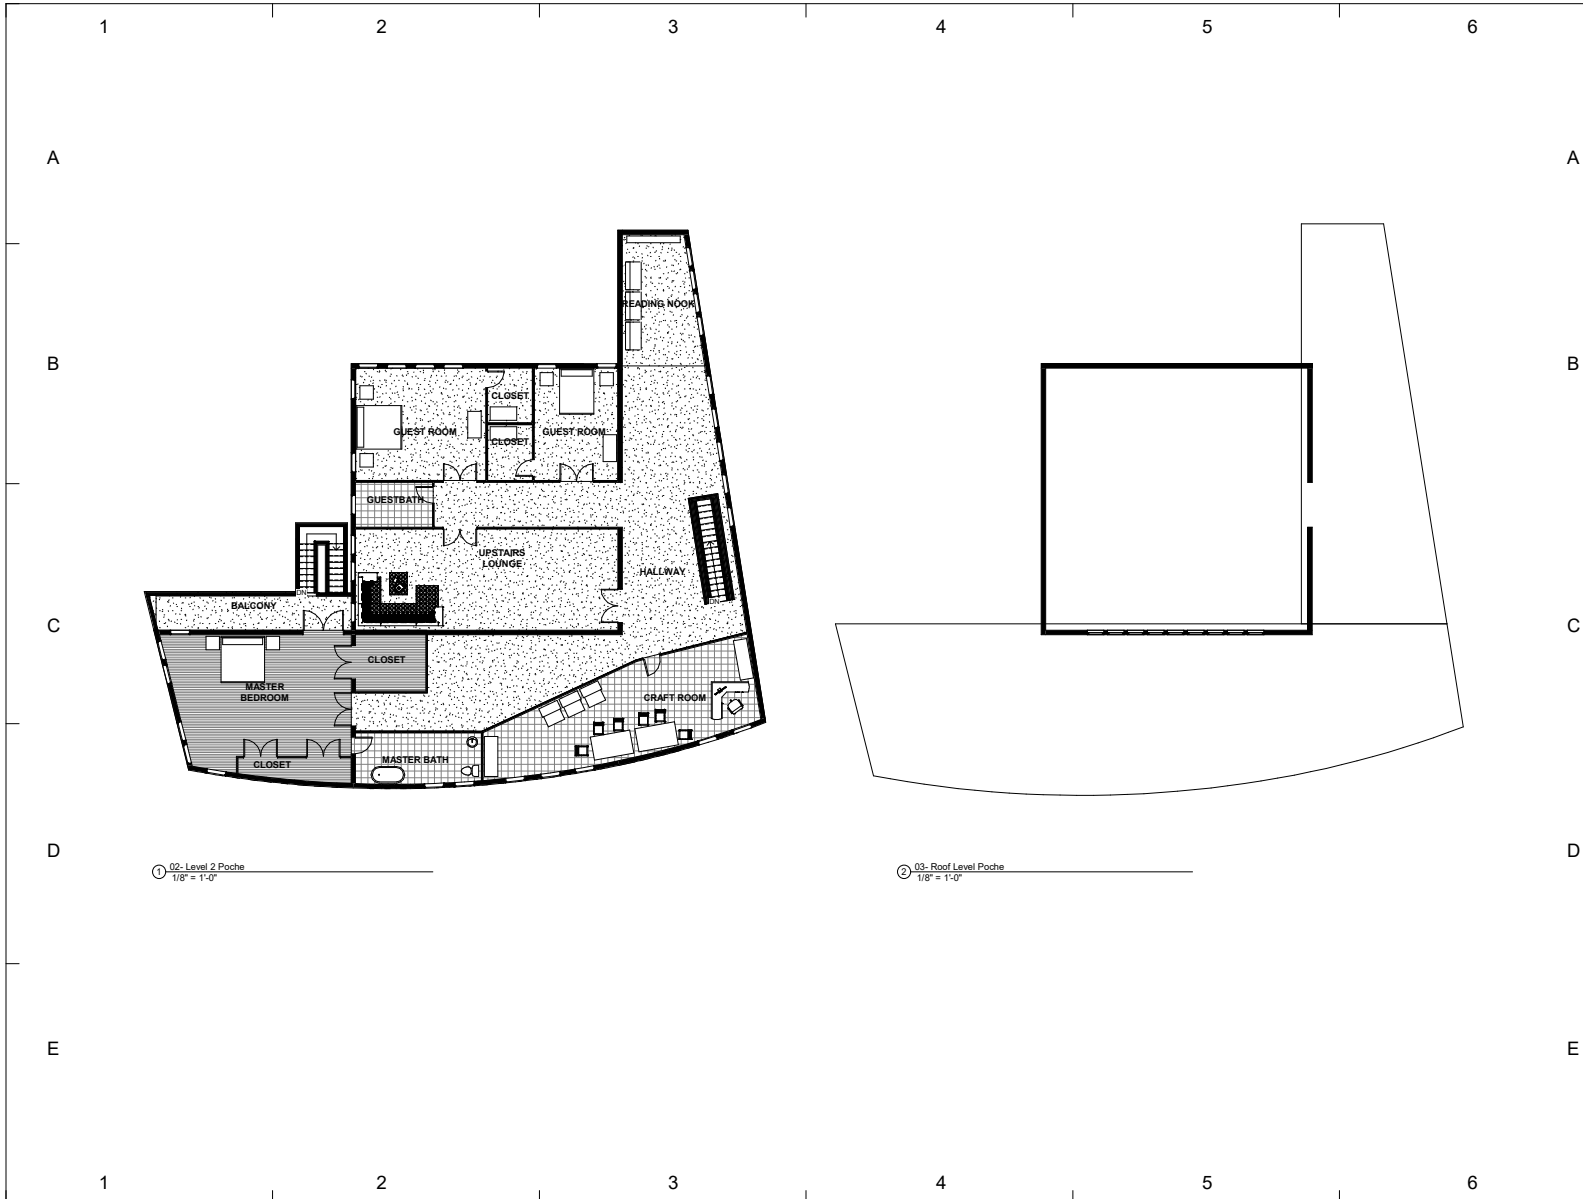

www.mollygildar.com

Consultant: INC ENGINEERING  
Address: 333 West state street  
Phone: 808 555 6509  
Fax: 1 808 555 6509  
e-mail: colorcompany@gmail.com




No.	Description	Date
1	House WEEK 5	09/18/20

House for week #5

Yiana Tjotjos  
Assignment #13  
Poche Plans

Project number	Assignment #13
Date	Issue Date
Drawn by	Molly Gildar
Checked by	Prof. Wacta
<b>A114</b>	
Scale	1/8" = 1'-0"

4/17/2020 04:52:04 PM

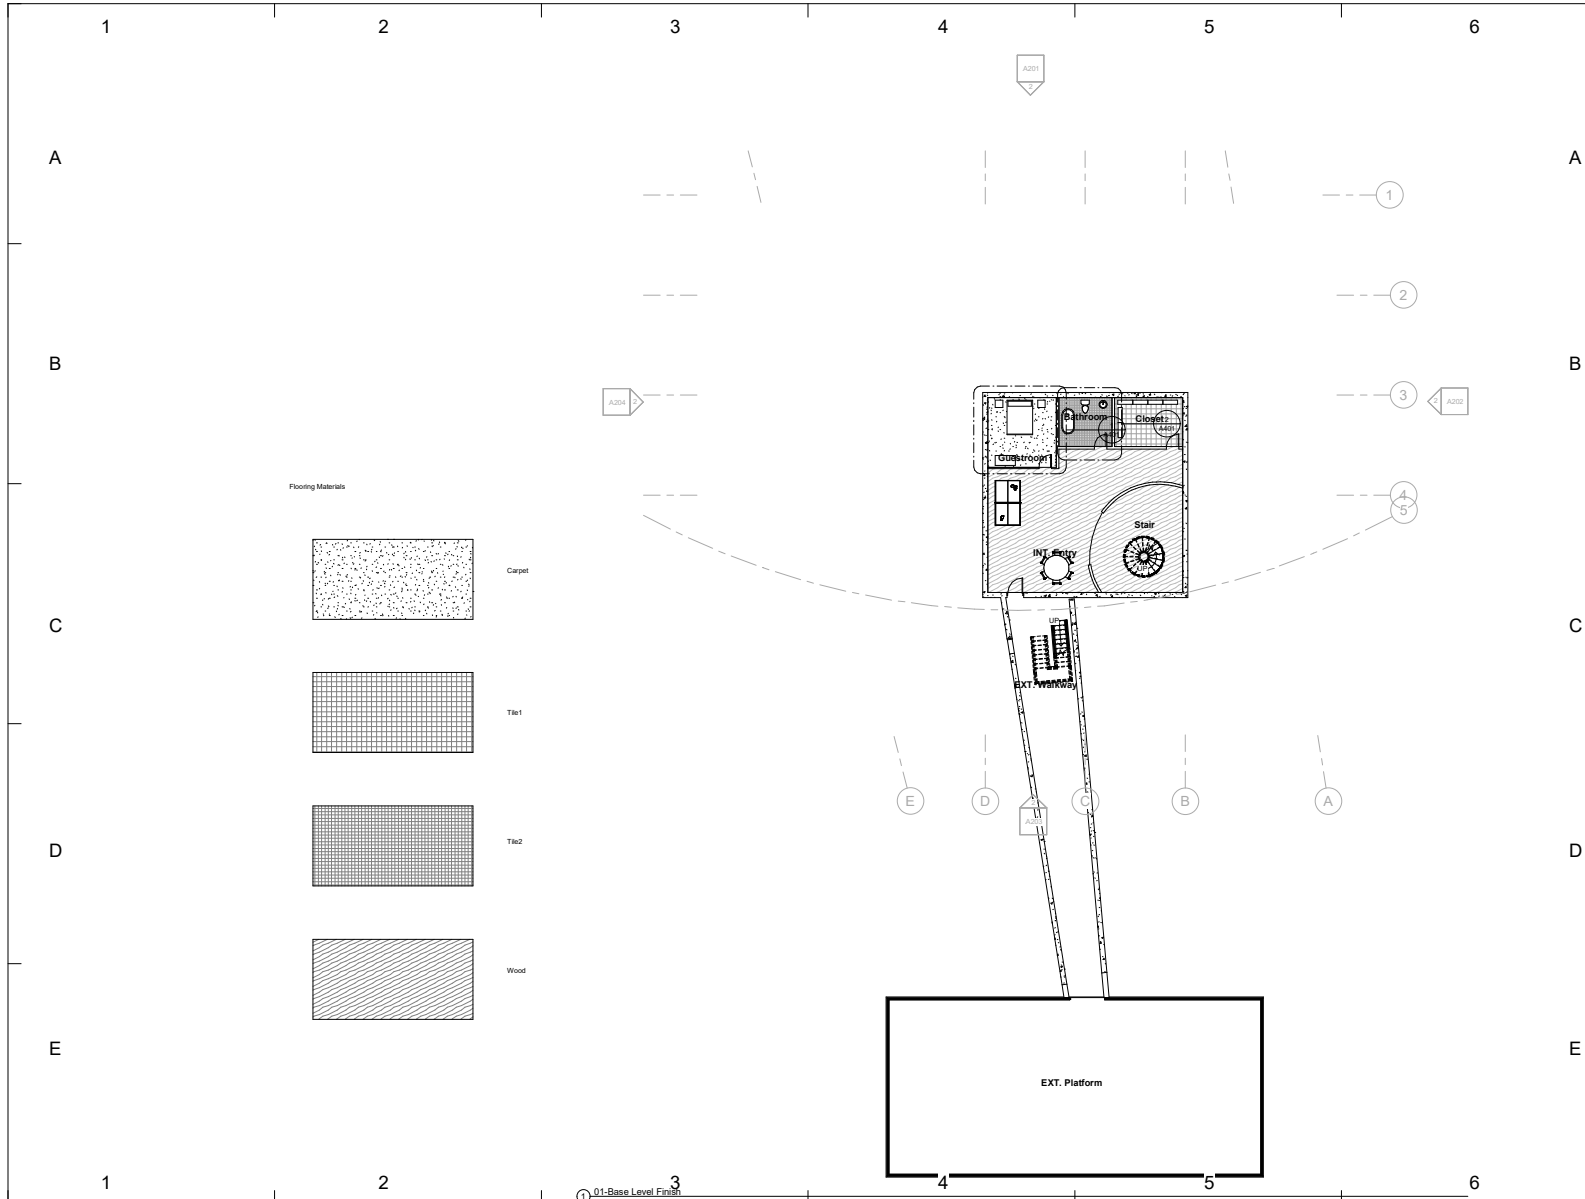

www.mollygildar.com

Consultant: INC ENGINEERING  
 Address: 333 West state street  
 Phone: 808 555 6509  
 Fax: 1 808 555 6509  
 e-mail: colorcompany@gmail.com



No.	Description	Date
1	House WEEK 5	09/18/20

House for week #5


Yiana Tjotjos  
 Assignment #13  
 Floor Plan Base Finish

Project number	Assignment #13
Date	Issue Date
Drawn by	Author
Checked by	Checker

A115


Scale As indicated

4/17/2020 9:42:08 AM

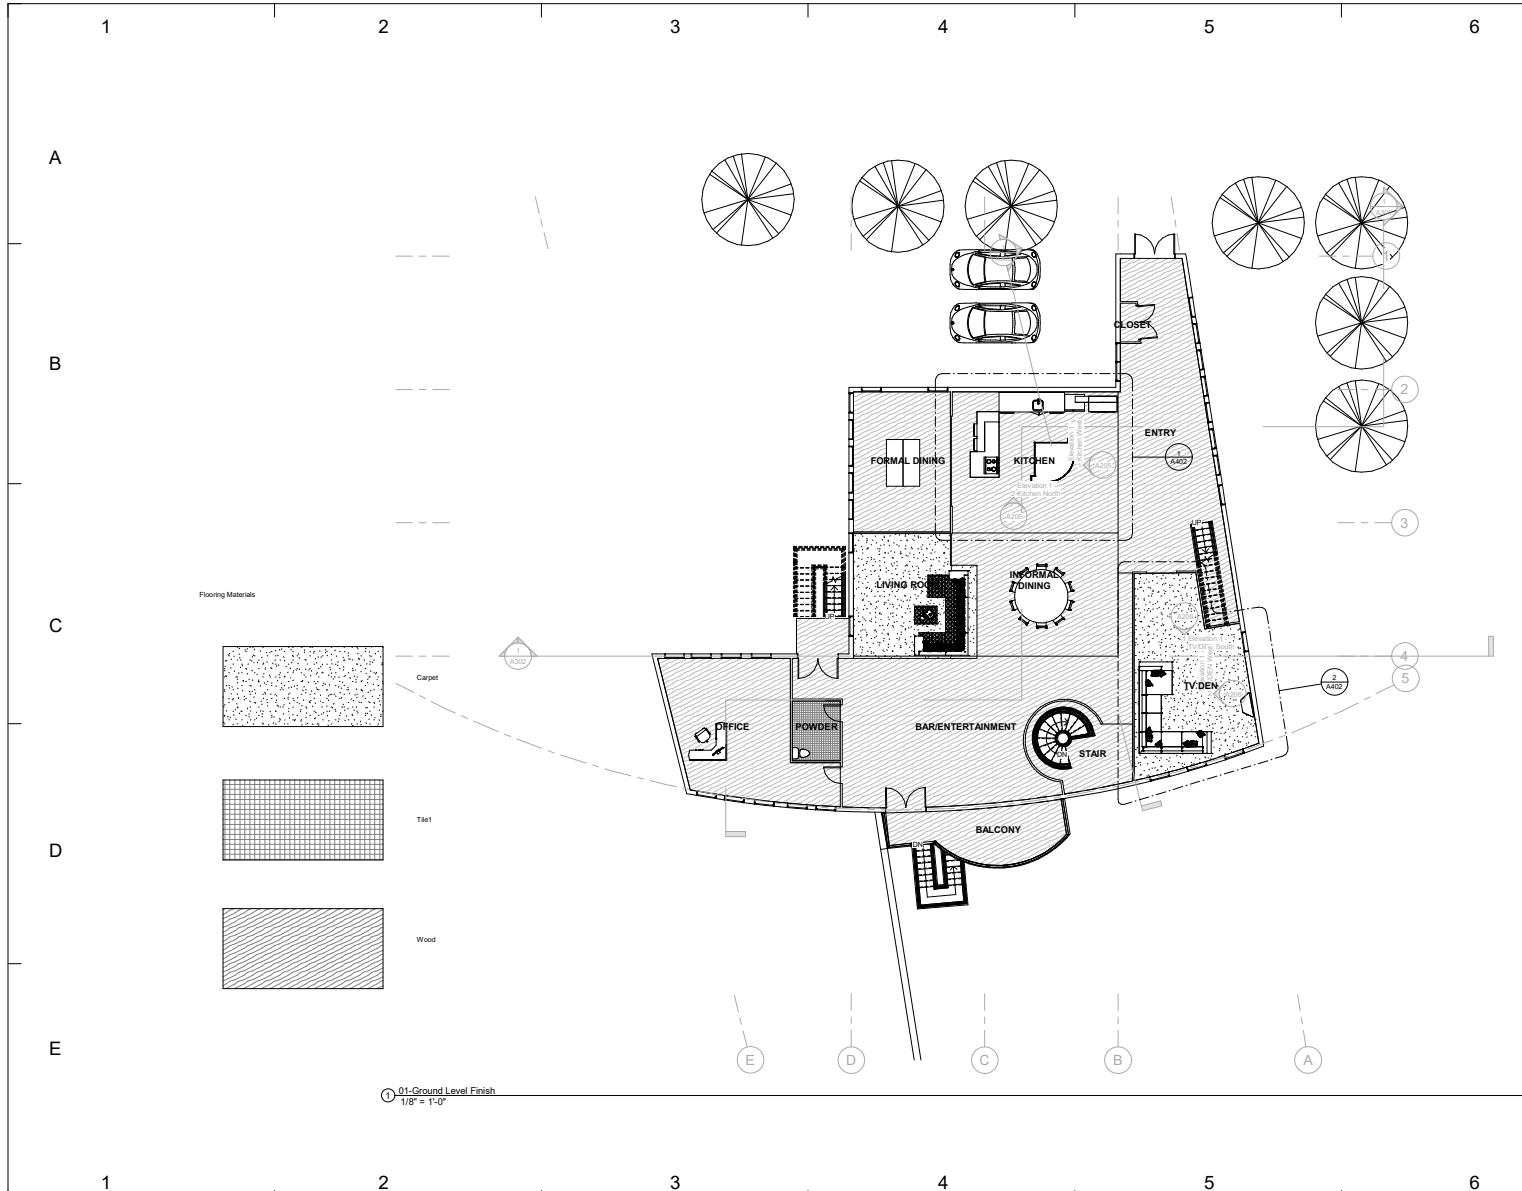

www.mollyglidar.com

 Consultant: INC ENGINEERING  
 Address: 333 West state street  
 Phone: 808 555 6909  
 Fax: 1 808 555 6509  
 e-mail: colorcompany@gmail.com



No.	Description	Date
1	House WEEK 5	09/18/20

House for week #5

Yiana Tjotjos  
 Assignment #13  
 Floor Plan Ground Finish

Project number: Assignment #13  
 Date: Issue Date  
 Drawn by: Molly Glidar  
 Checked by: Prof. Wacta

 
**A116**  
 Scale: As indicated

4/17/2020 9:42:29 AM



www.mollygildar.com

Consultant: INC ENGINEERING  
 Address: 333 West state street  
 Phone: 808 555 6509  
 Fax: 1 808 555 6509  
 e-mail: colorcompany@gmail.com



No.	Description	Date
1	House WEEK 5	09/18/20

House for week #5


Yiana Tjotjos  
 Assignment #13  
 Floor Plan Level 2  
 Finish

Project number: Assignment #13  
 Date: Issue Date  
 Drawn by: Molly Gildar  
 Checked by: Prof. Wacta


**A117**

Scale: As indicated

4/17/2020 9:45:32 PM

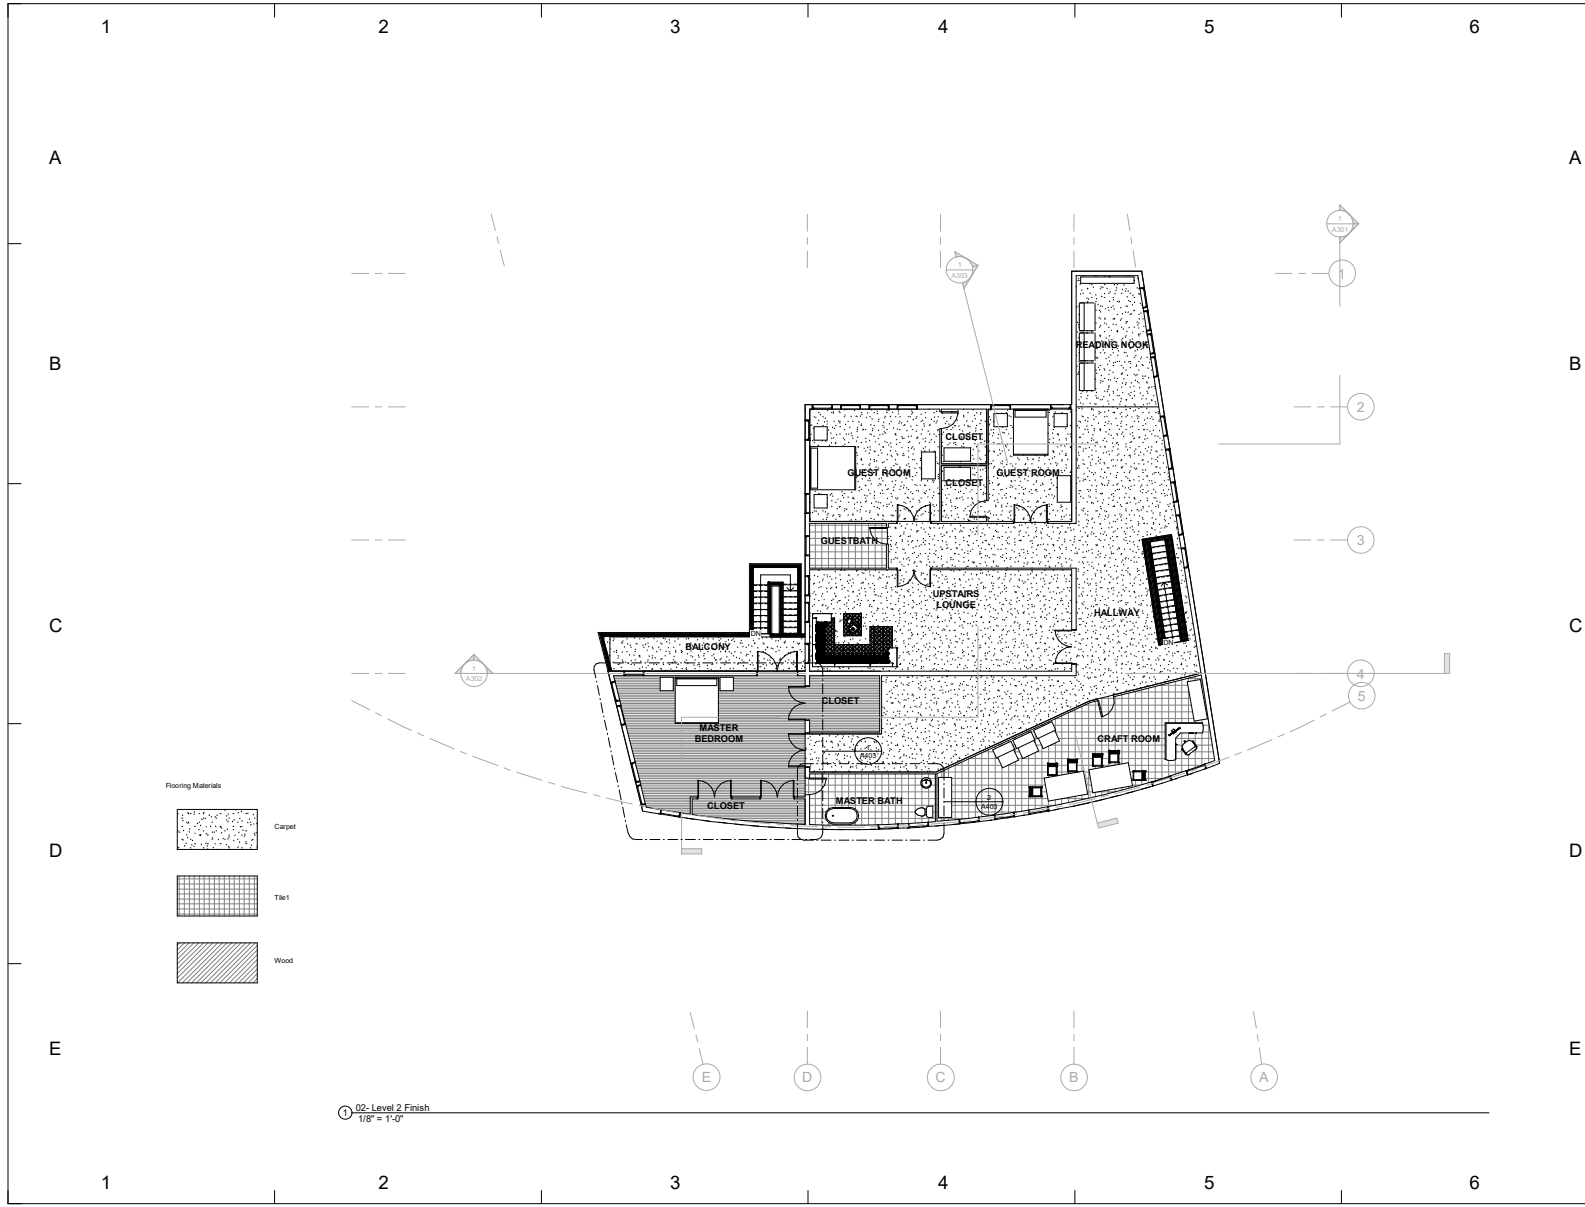



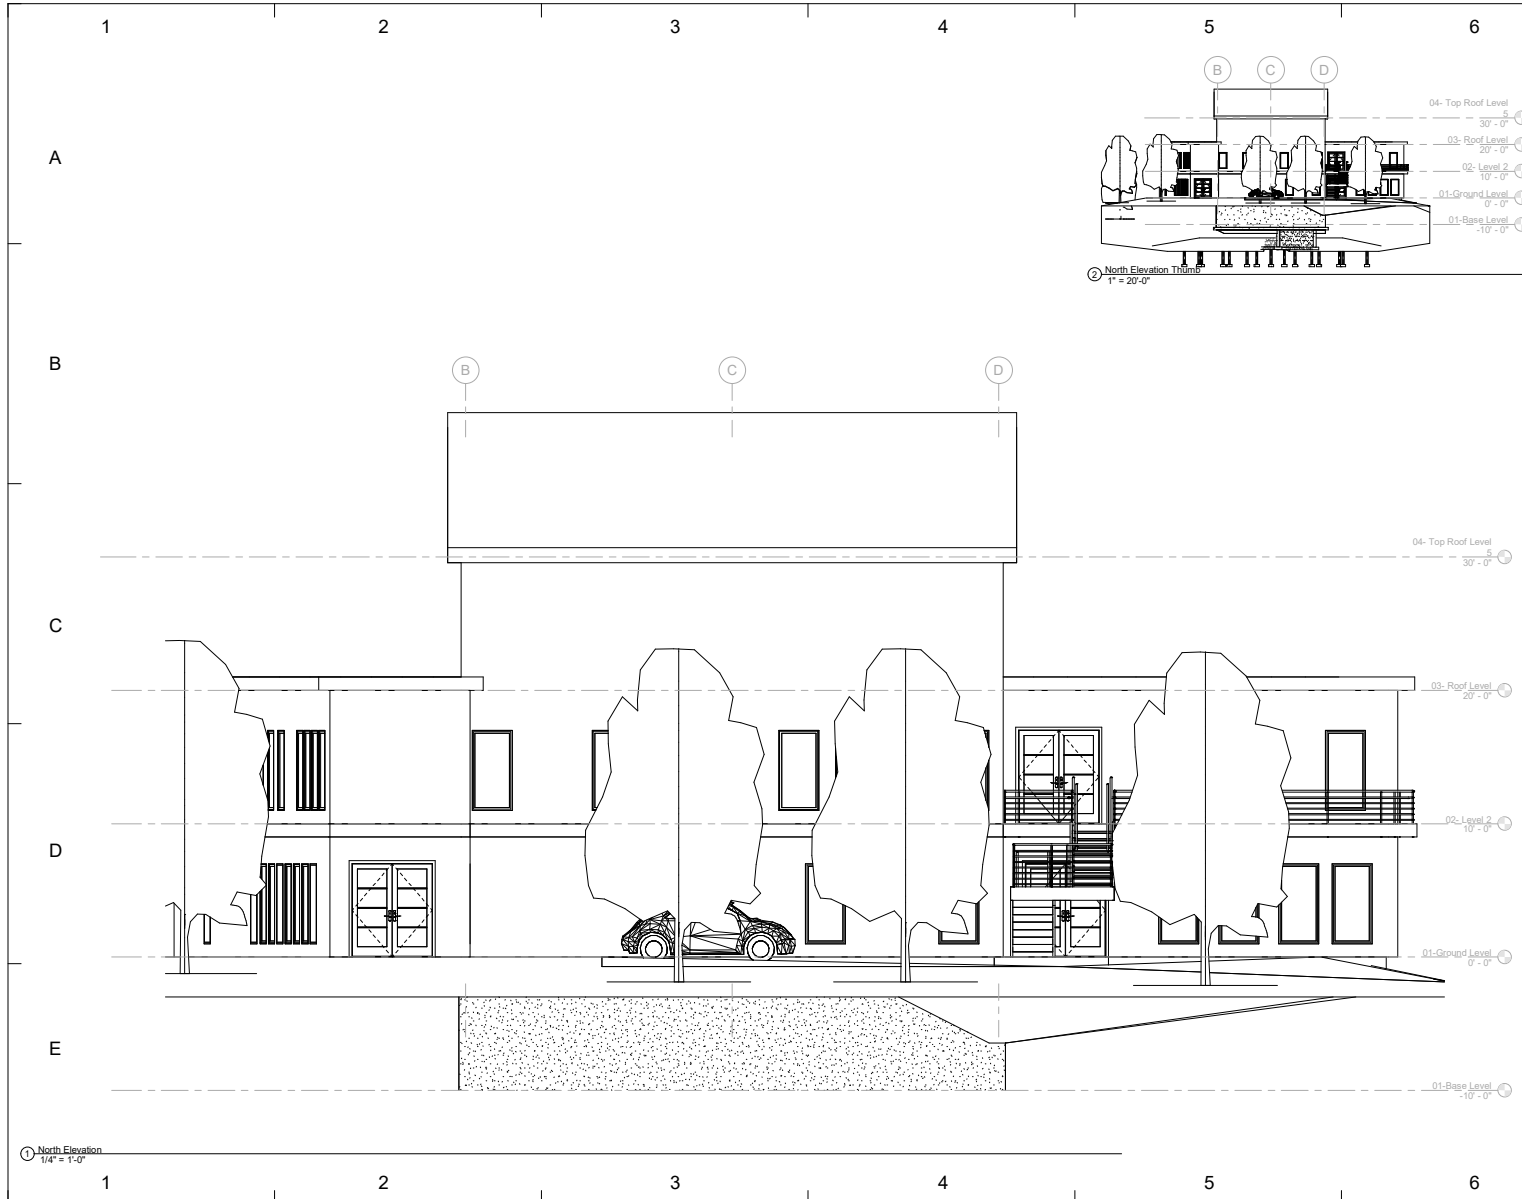

www.mollygildar.com

Consultant: INC ENGINEERING  
 Address: 333 West state street  
 Phone: 808 555 6509  
 Fax: 1 808 555 6509  
 e-mail: colorcompany@gmail.com





No.	Description	Date
1	House WEEK 5	09/18/20

House for week #5


Yiana Tjotjos  
 Assignment #13  
 North Elevation

Project number	Assignment #13
Date	Issue Date
Drawn by	Molly Gildar
Checked by	Prof. Wacta
<b>A201</b>	
Scale	As indicated

4/17/2020 9:45:36 AM

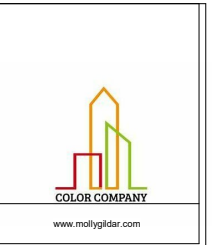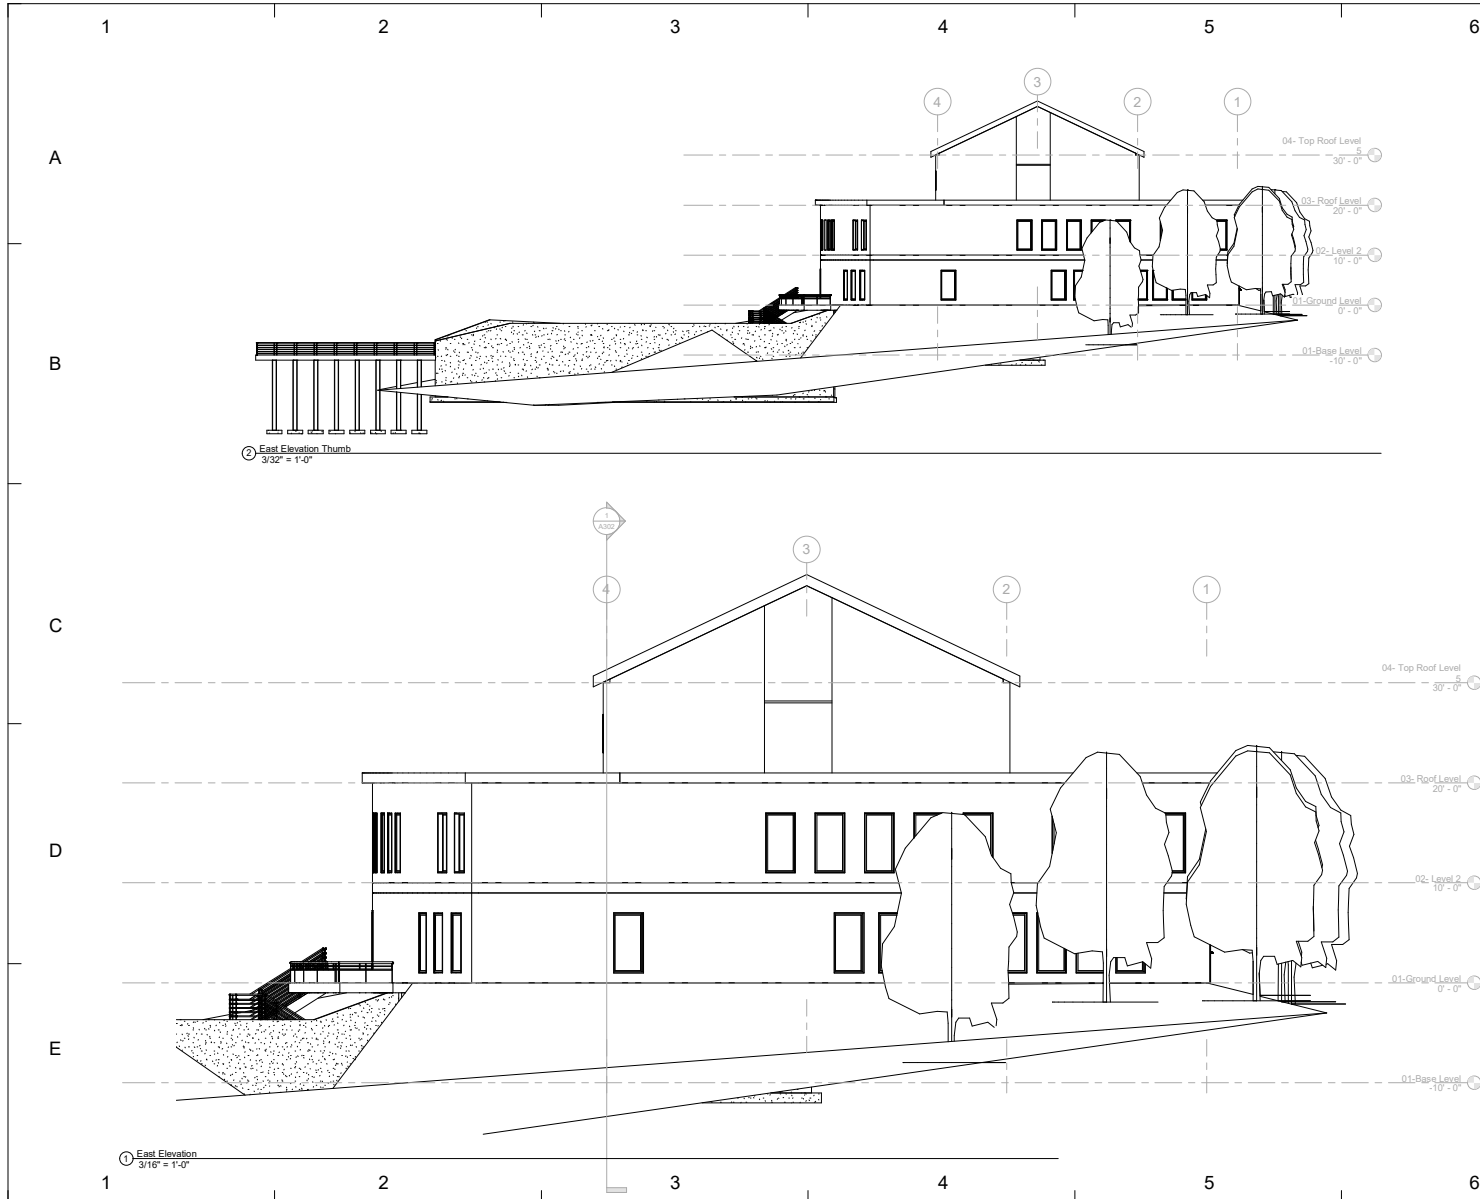

Consultant: INC ENGINEERING  
 Address: 333 West state street  
 Phone: 808 555 6509  
 Fax: 1 808 555 6509  
 e-mail: colorcompany@gmail.com

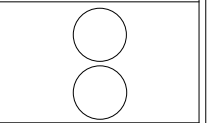

No.	Description	Date
1	House WEEK 5	09/18/20



House for week #5

**Yiana Tjotjos**  
**Assignment #13**  
**East Elevation**


Project number: Assignment #13  
 Date: \_\_\_\_\_ Issue Date  
 Drawn by: Molly Glidar  
 Checked by: Prof. Wacta

A202

Scale: \_\_\_\_\_ As indicated

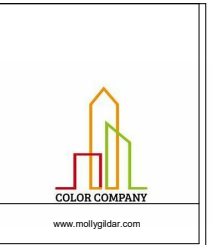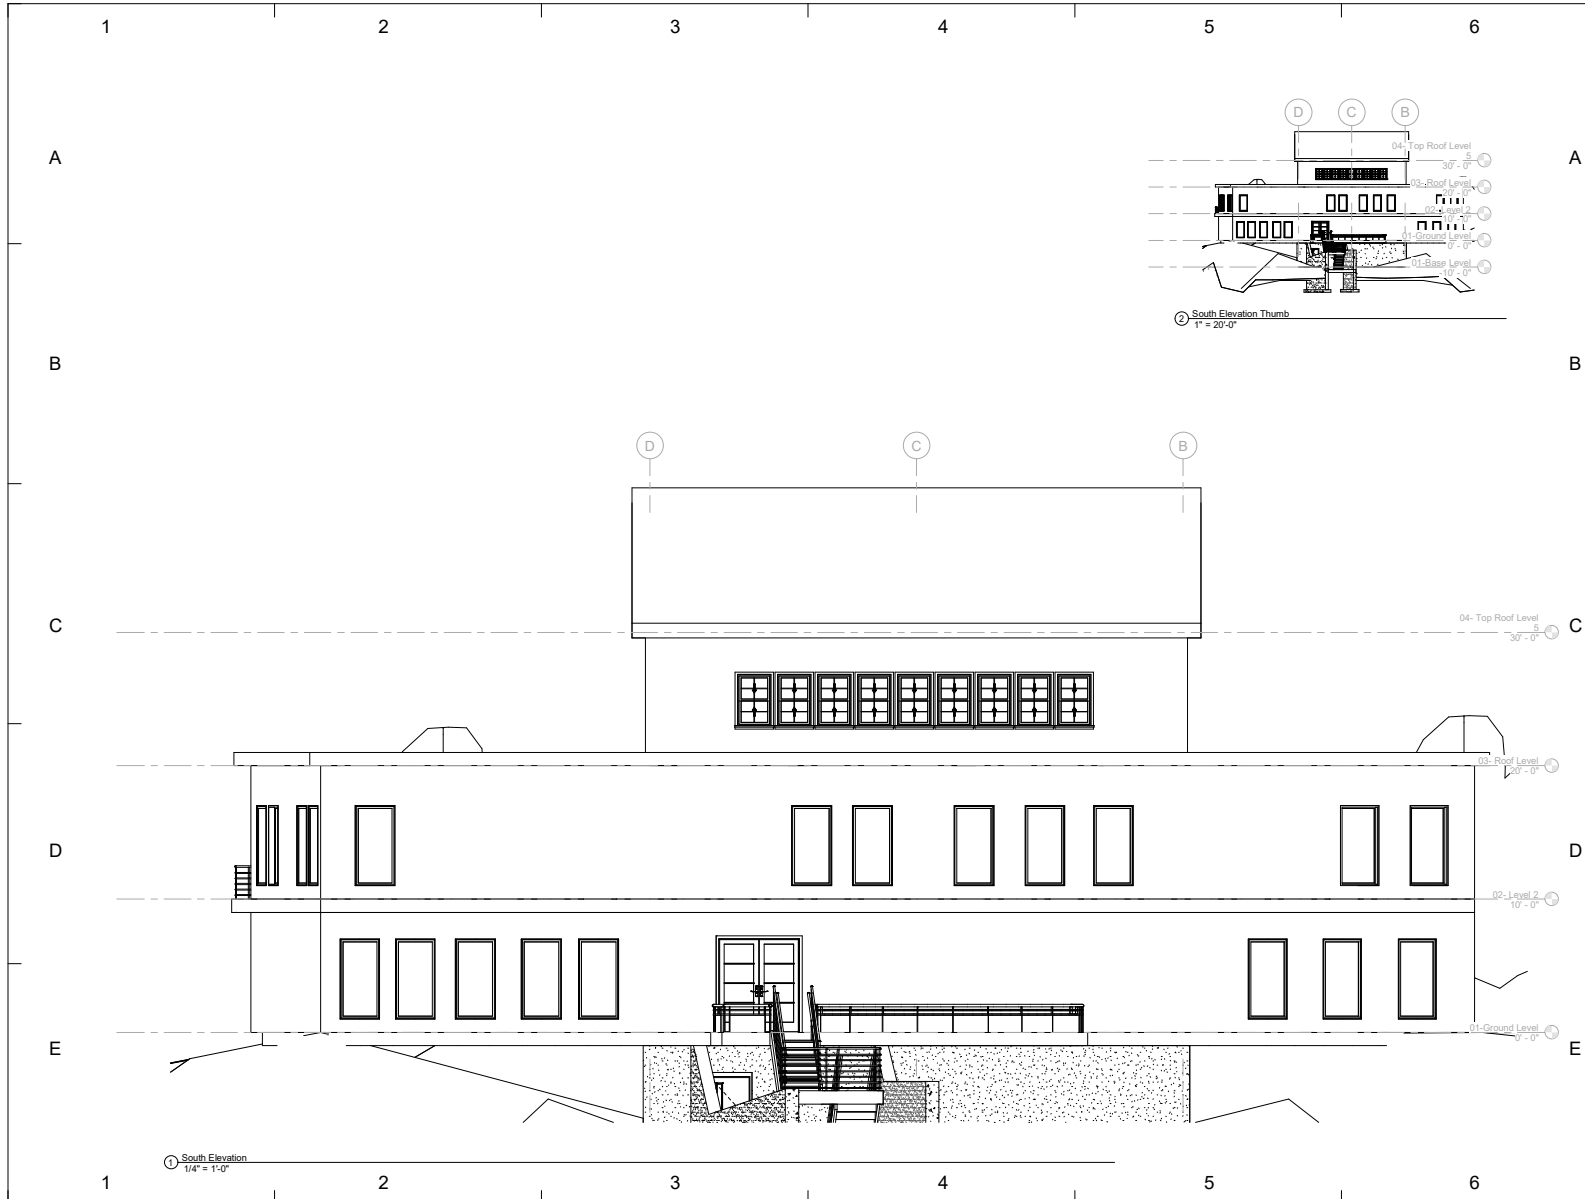

Consultant: INC ENGINEERING  
 Address: 333 West state street  
 Phone: 808 555 6509  
 Fax: 1 808 555 6509  
 e-mail: colorcompany@gmail.com

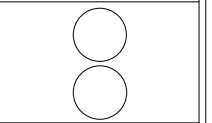


No.	Description	Date
1	House WEEK 5	09/18/20

House for week #5

Yiana Tjoṭjos  
 Assignment #13  
 South Elevation


Project number	Assignment #13
Date	Issue Date
Drawn by	Molly Gildar
Checked by	Prof. Wacta
<b>A203</b>	
Scale	As indicated

4/17/2020 04:40 PM

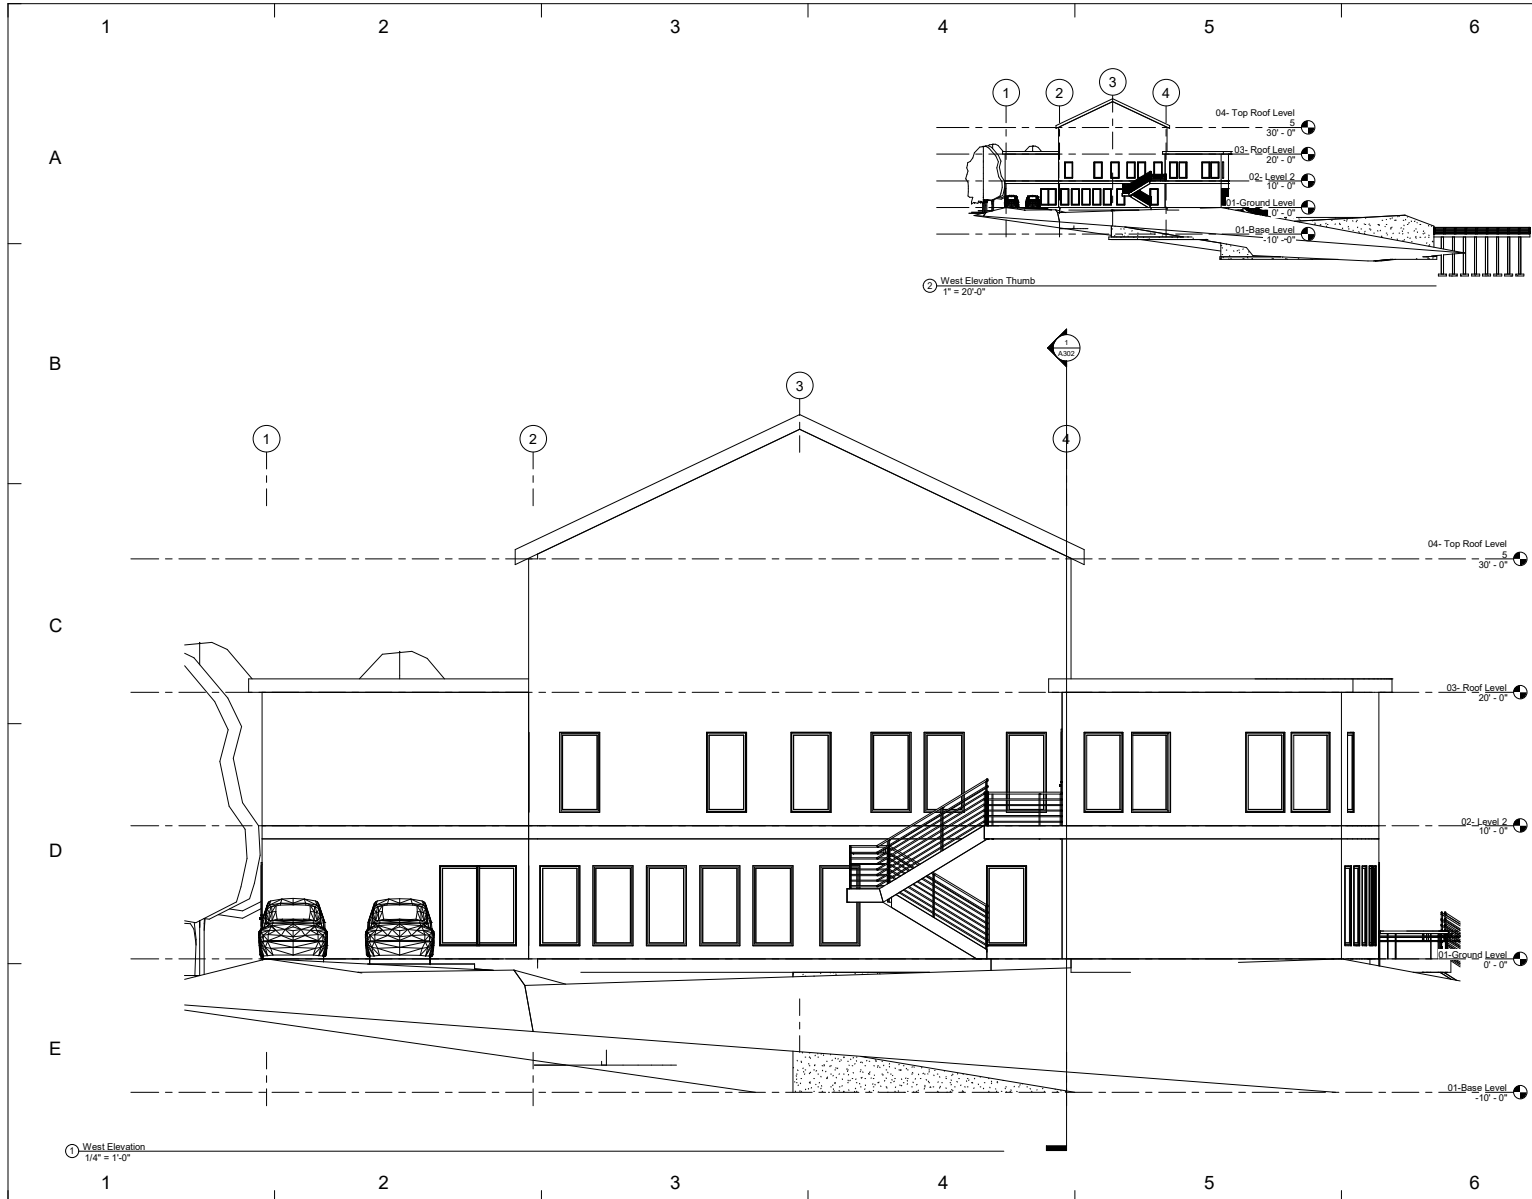

**COLOR COMPANY**  
www.mollygidar.com

Consultant: INC ENGINEERING  
Address: 333 West state street  
Phone: 808 555 6509  
Fax: 1 808 555 6509  
e-mail: colorcompany@gmail.com

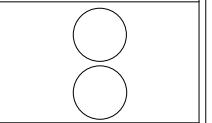


No.	Description	Date
1	House WEEK 5	09/18/20

House for week #5


Yiana Tjoṭjos  
Assignment #13  
West Elevation

Project number	Assignment #13
Date	Issue Date
Drawn by	Molly Gildar
Checked by	Prof. Wacta
<b>A204</b>	
Scale	As indicated

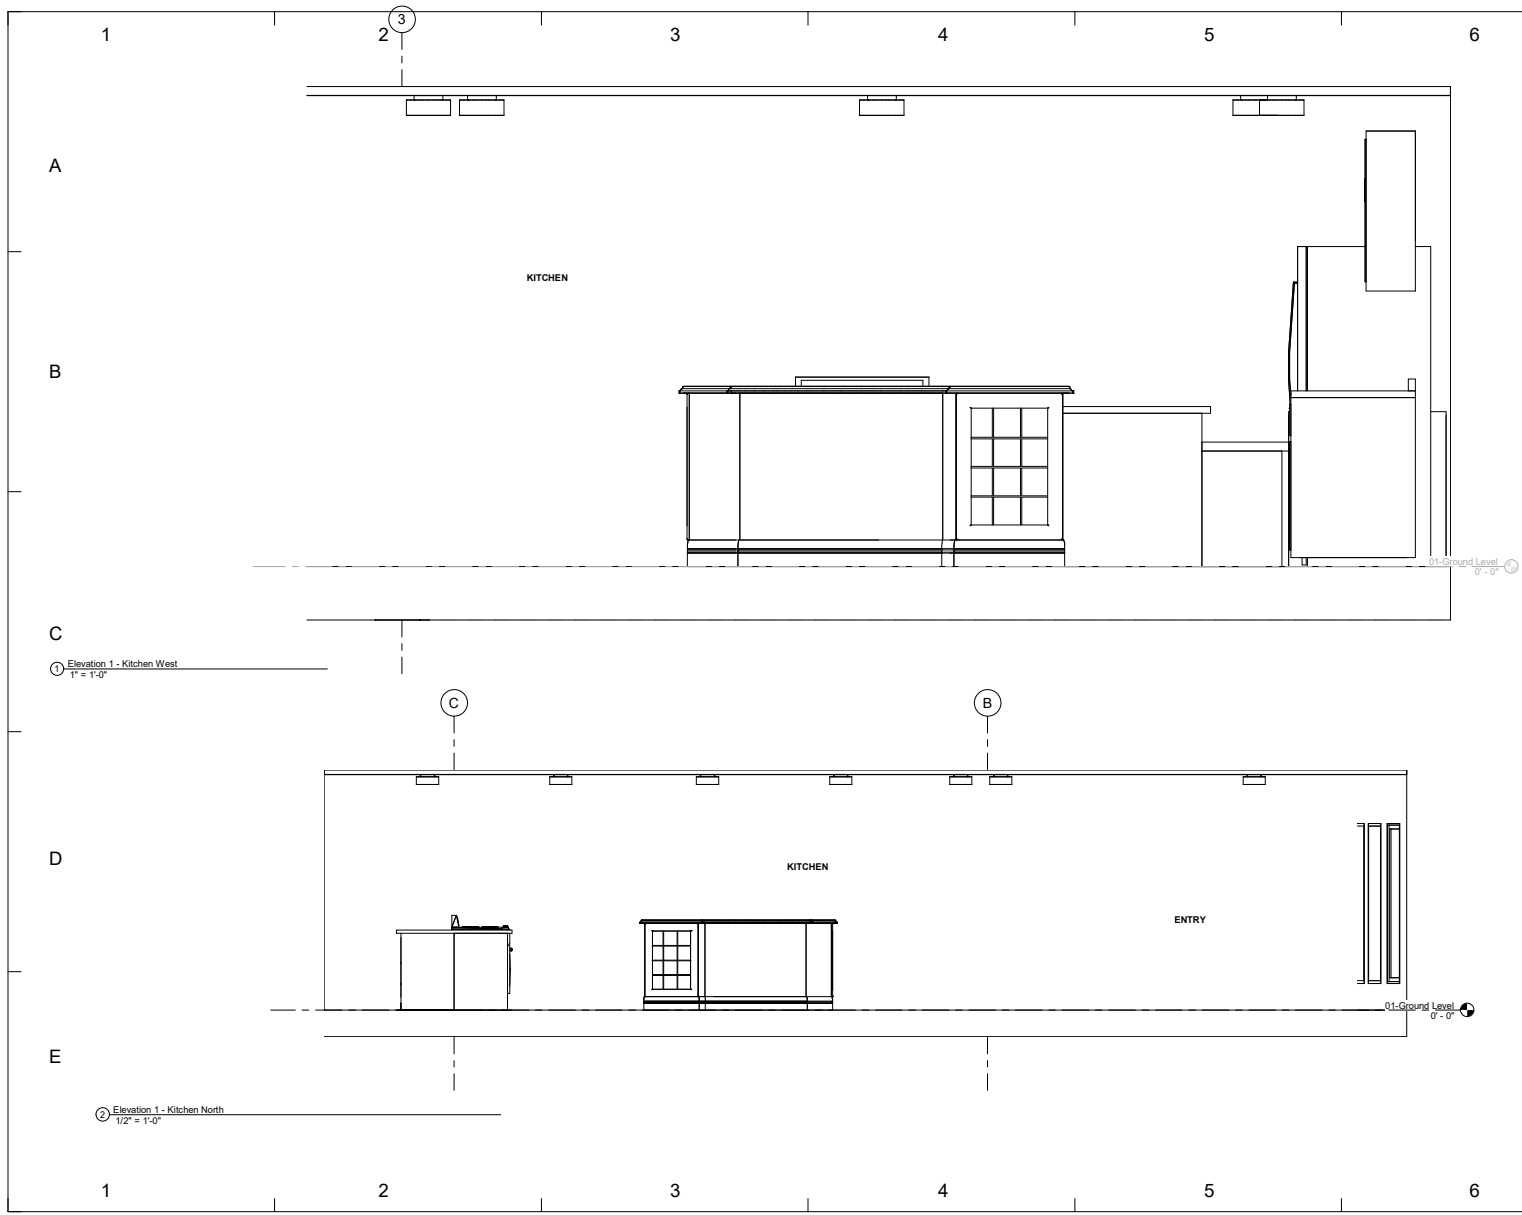

www.mollygildar.com

 Consultant: INC ENGINEERING  
 Address: 333 West state street  
 Phone: 808 555 6509  
 Fax: 1 808 555 6509  
 e-mail: colorcompany@gmail.com



No.	Description	Date
1	House WEEK 5	09/18/20
2	House week 6	
3	House week 7	
4	House week 8	
5	House week 11	
6	House week 12	
7		

House for week #5


Yiana Tjotjos  
 Assignment #13  
 Interior  
 Elevation-KITCHEN


Project number: Assignment #13  
 Date: Issue Date  
 Drawn by: Molly Gildar  
 Checked by: Prof. Wacta

**A205**

Scale: As indicated

4/17/2020 04:54:33 PM

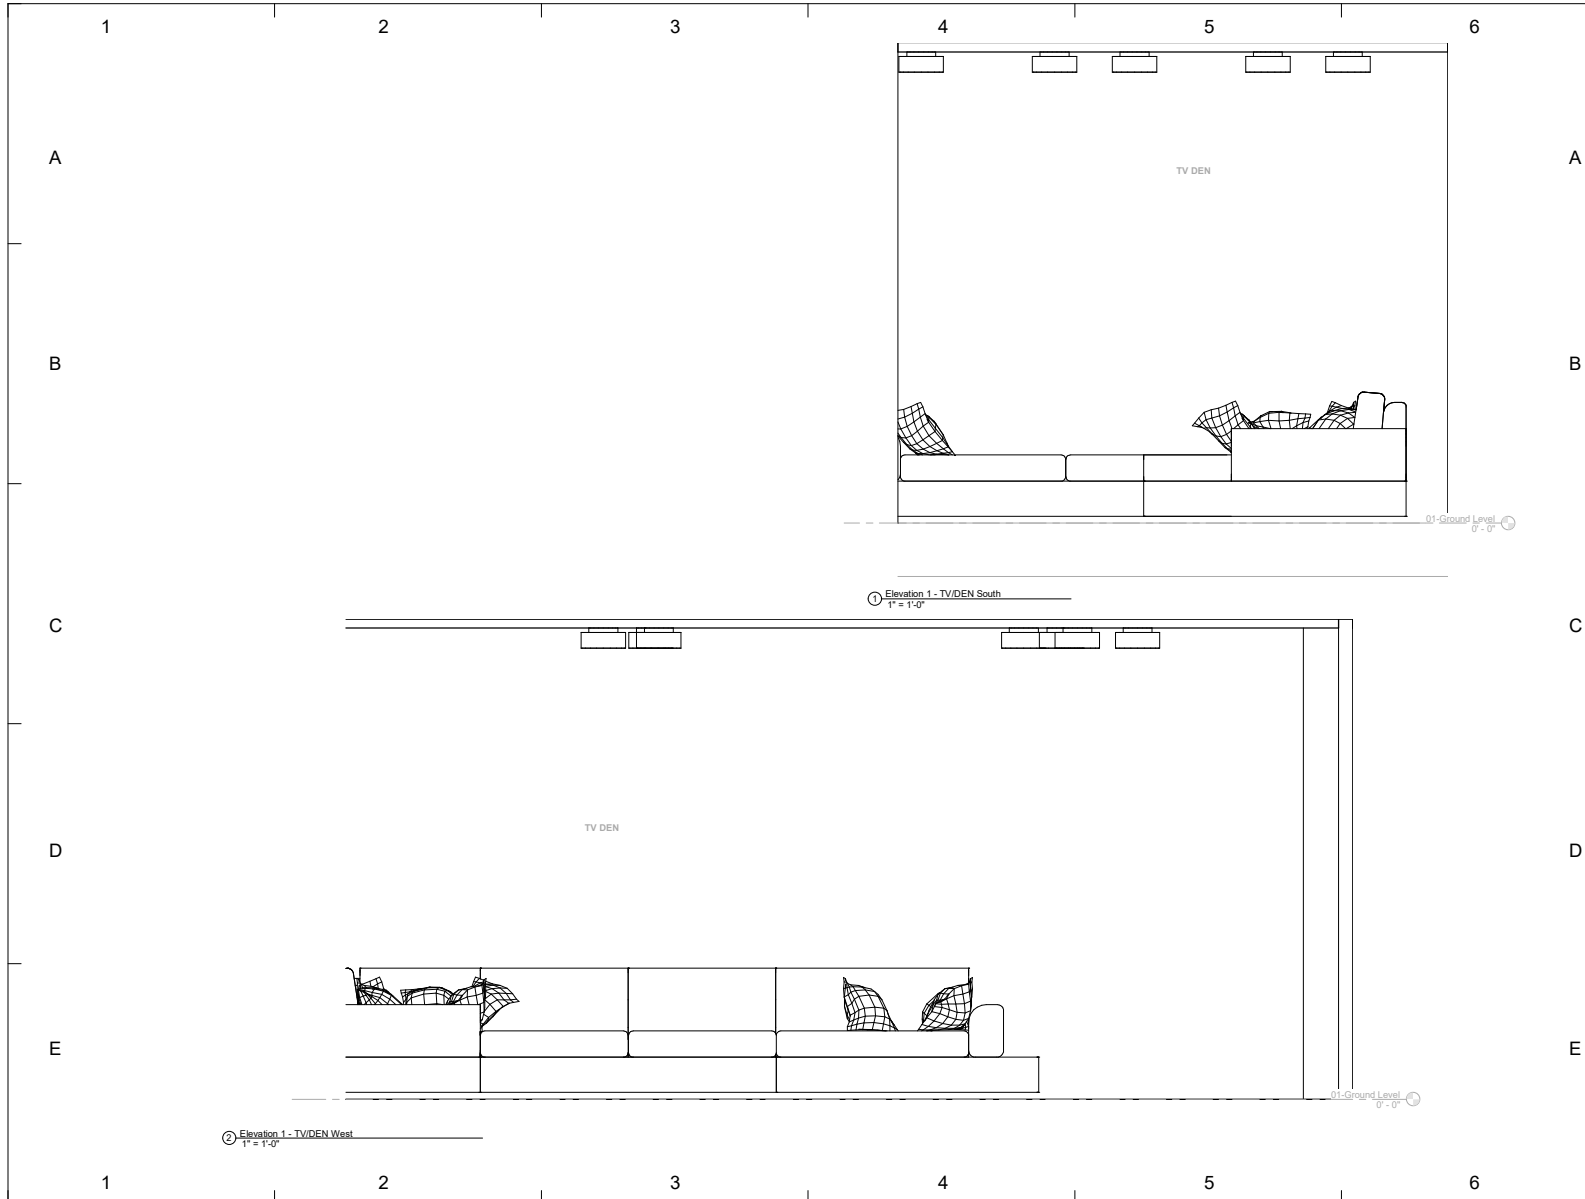



**COLOR COMPANY**

www.mollygildar.com


Consultant: INC ENGINEERING  
 Address: 333 West state street  
 Phone: 808 555 6509  
 Fax: 1 808 555 6509  
 e-mail: colorcompany@gmail.com


No.	Description	Date
1	House WEEK 5	09/18/20

House for week #5

**Yiana Tjotjos**  
 Assignment #13  
 Interior  
 Elevation-TV/DEN

Project number	Assignment #13
Date	Issue Date
Drawn by	Author
Checked by	Checker
A206	
Scale	1" = 1'-0"

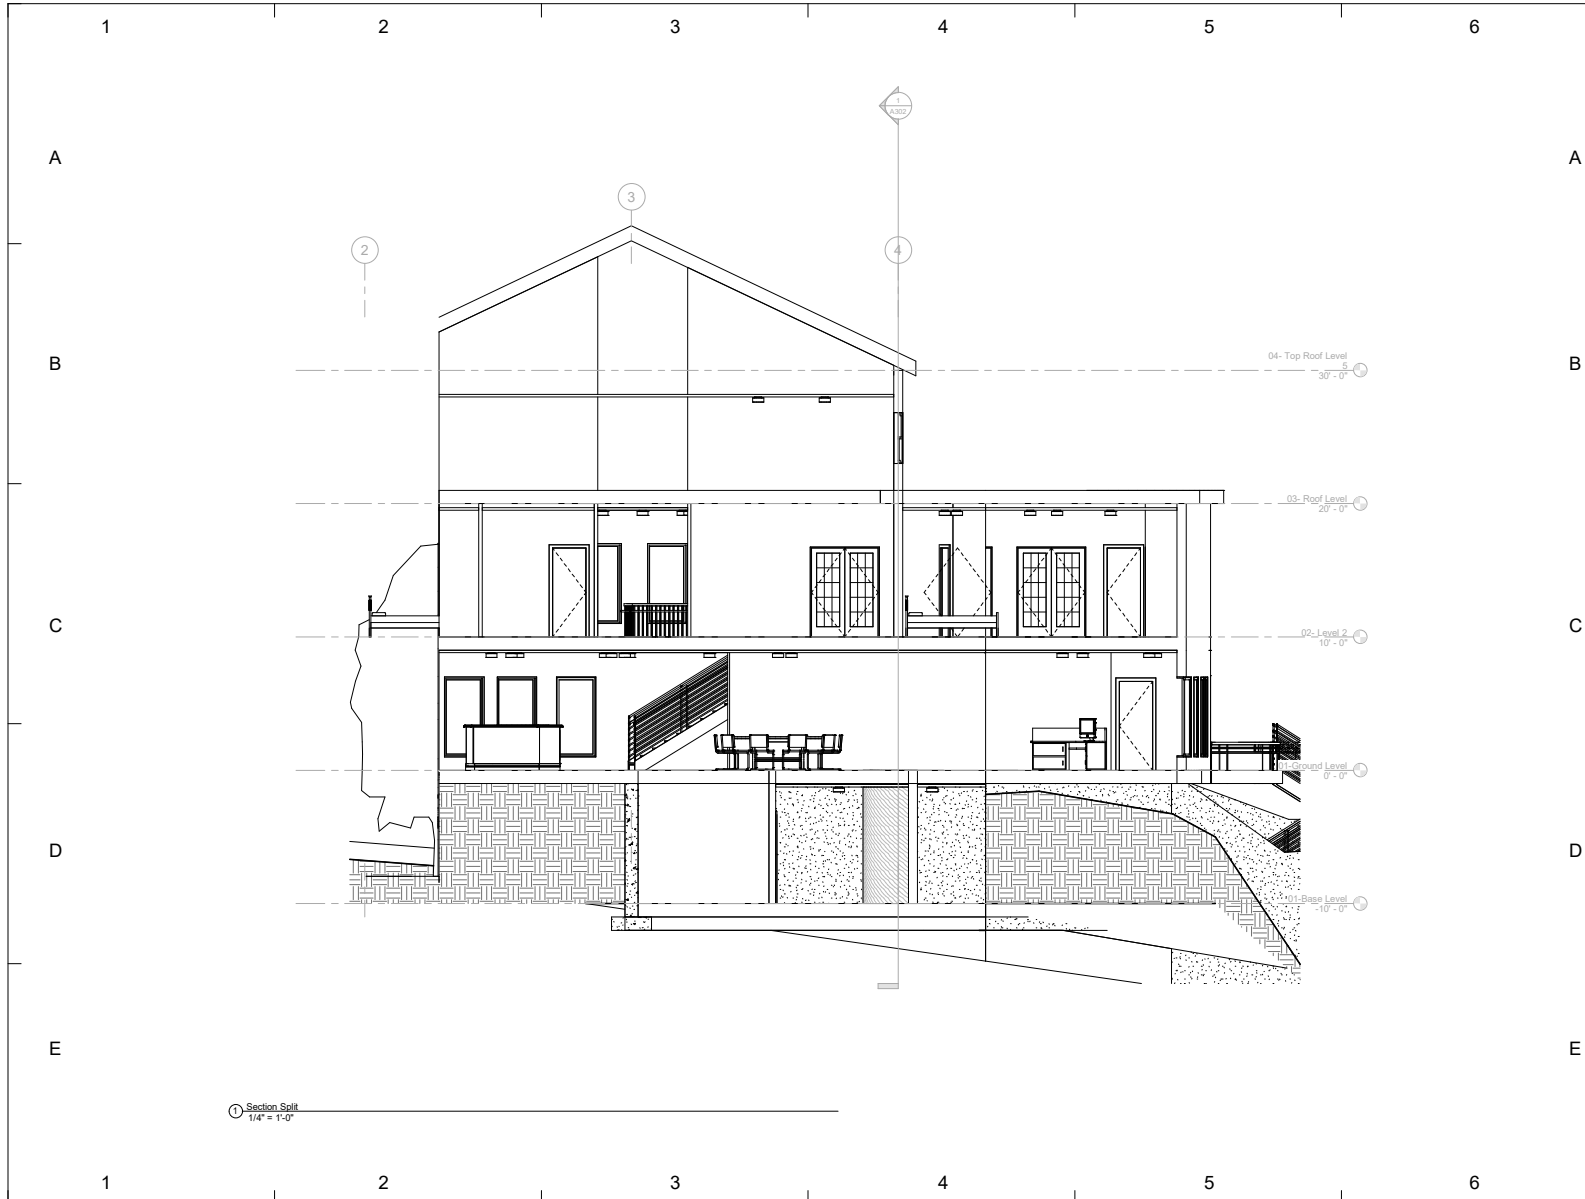




**COLOR COMPANY**

www.mollygildar.com

---

Consultant: INC ENGINEERING  
 Address: 333 West state street  
 Phone: 808 555 6509  
 Fax: 1 808 555 6509  
 e-mail: colorcompany@gmail.com

 ---



---

No.	Description	Date
1	House WEEK 5	09/18/20

---

House for week #5


---

Yiana Tjotjos  
 Assignment #13  
 Section

---

Project number	Assignment #13
Date	Issue Date
Drawn by	Author
Checked by	Checker
A301	
Scale	1/4" = 1'-0"

4/17/2020 04:54:56 PM

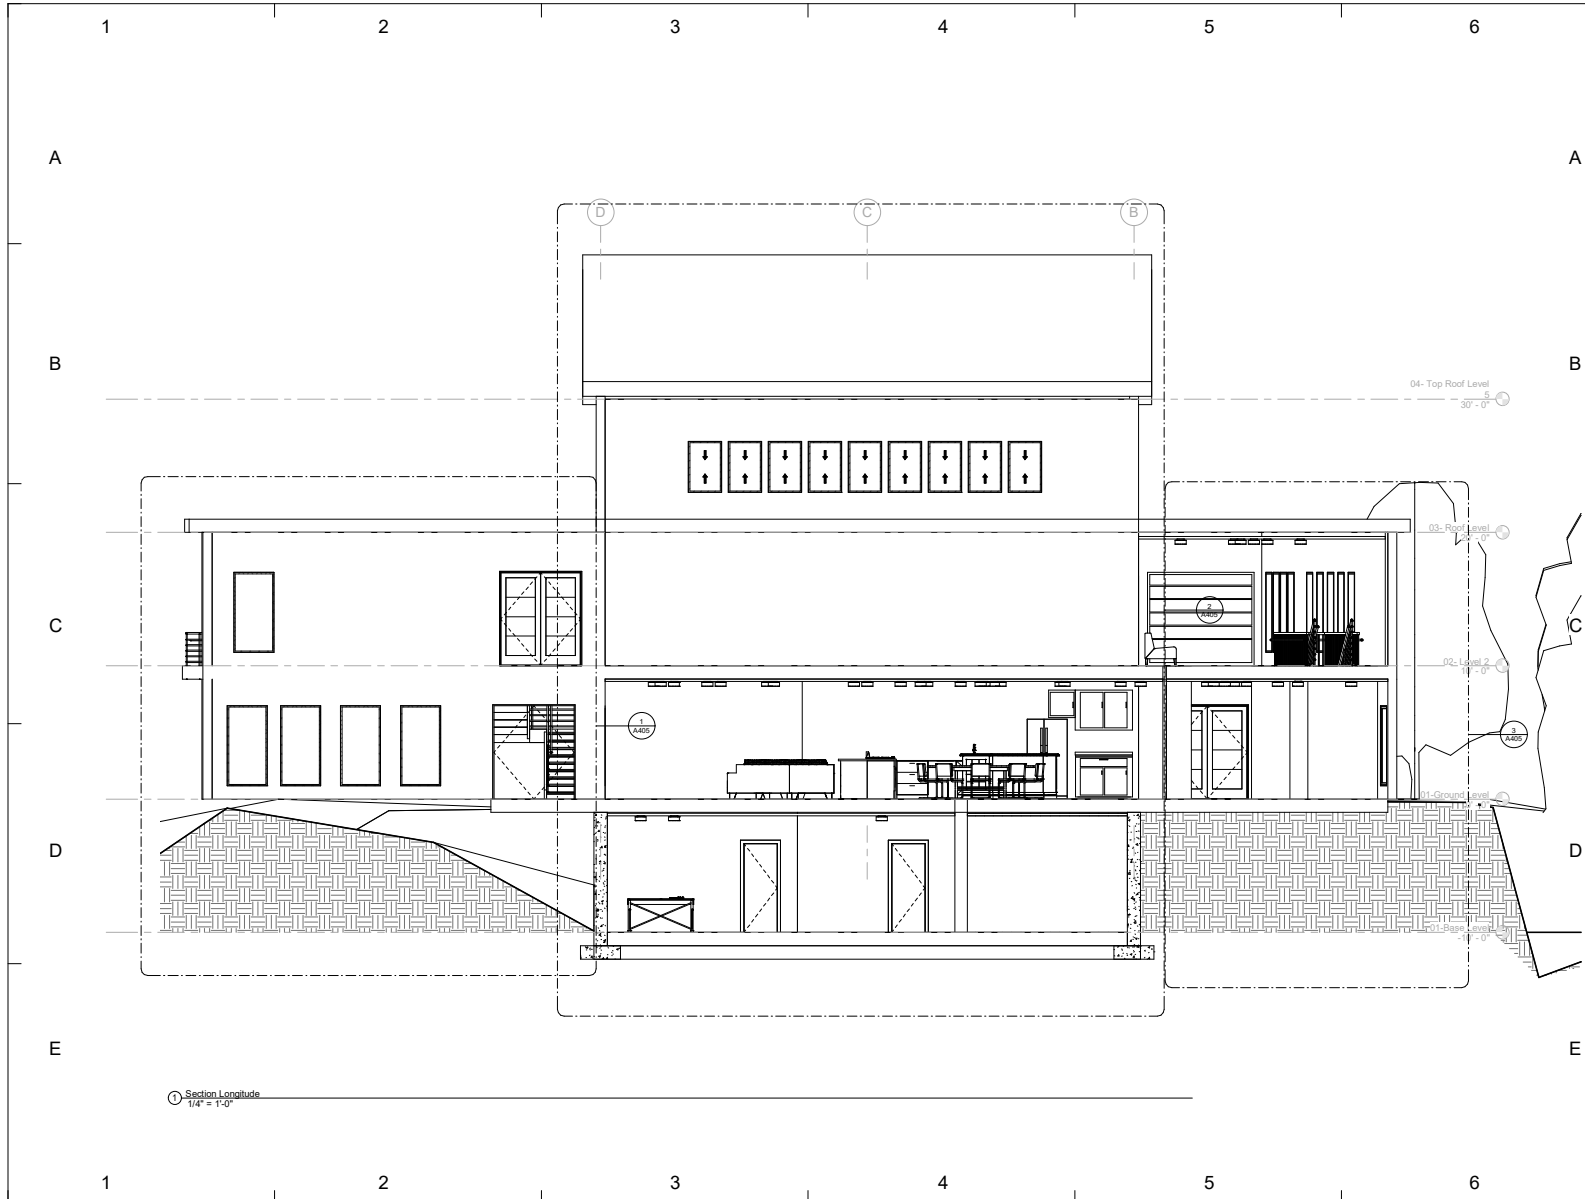

www.mollygildar.com

Consultant: INC ENGINEERING  
 Address: 333 West state street  
 Phone: 808 555 6509  
 Fax: 1 808 555 6509  
 e-mail: colorcompany@gmail.com



No.	Description	Date
1	House WEEK 5	09/18/20


House for week #5

Yiana Tjoṭjos  
 Assignment #13  
 Section

Project number	Assignment #13
Date	Issue Date
Drawn by	Author
Checked by	Checker
<b>A302</b>	
Scale	1/4" = 1'-0"

4/17/2020 04:47 PM



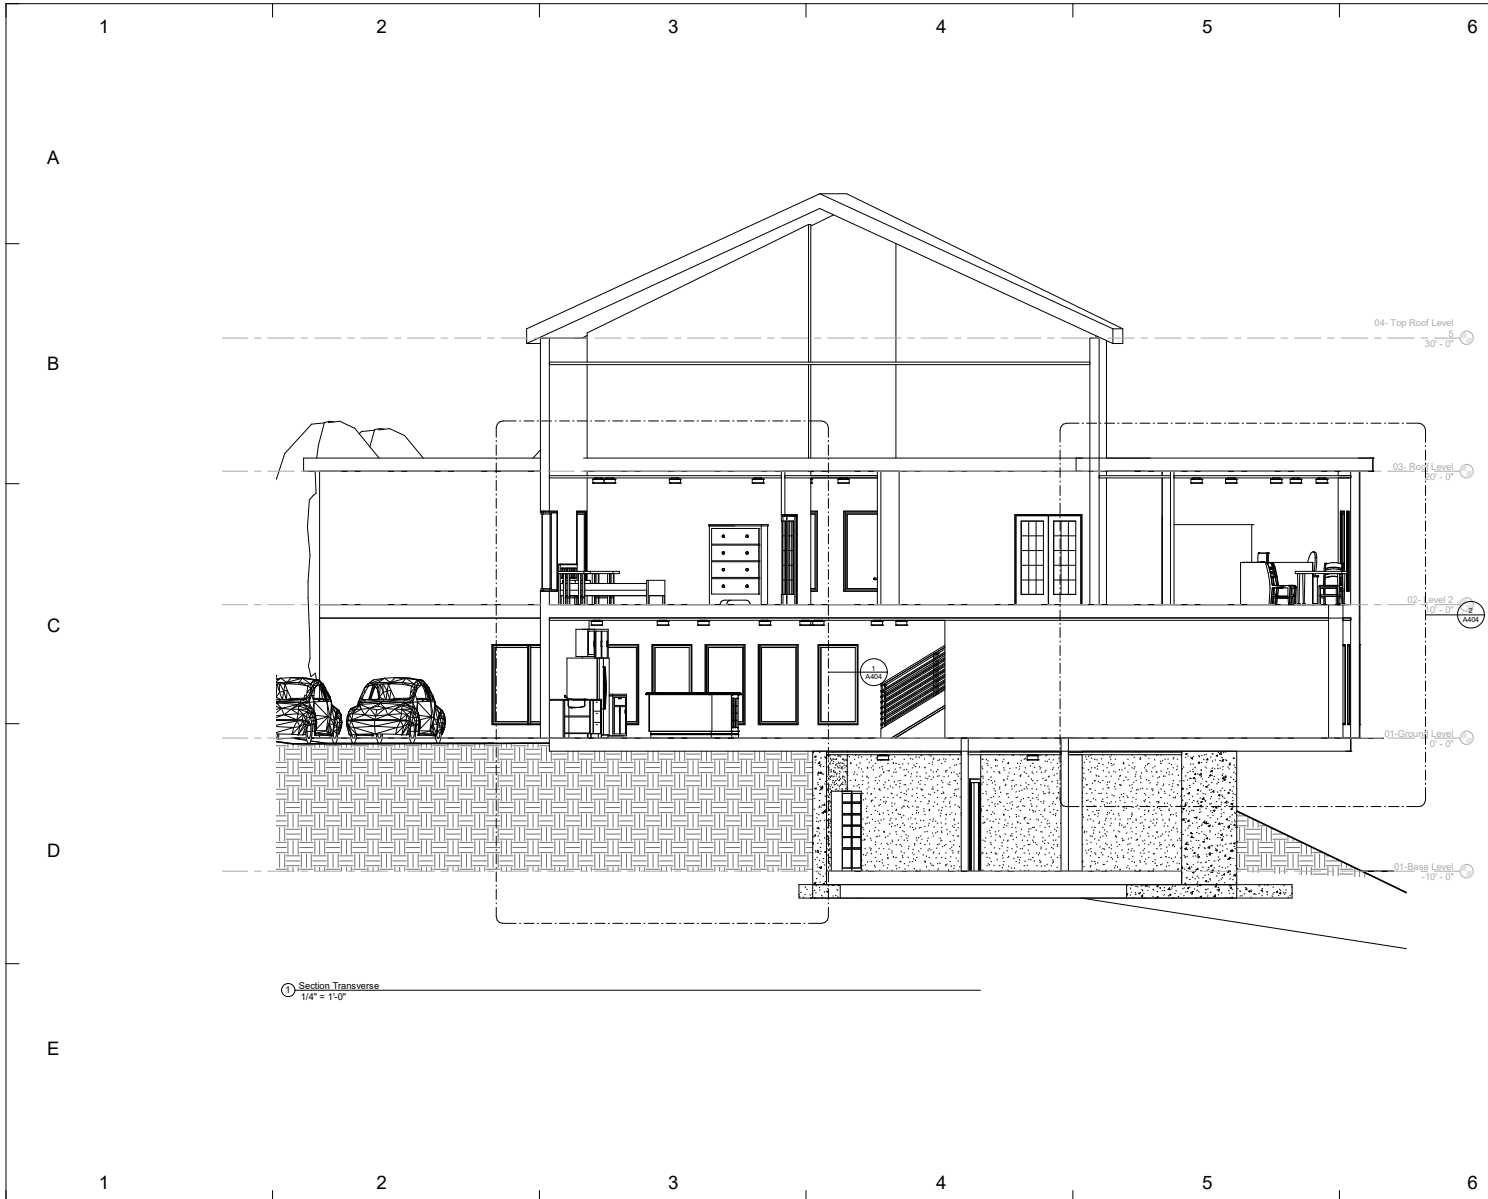

1 Section Transverse  
1/4" = 1'-0"



www.mollygildar.com

Consultant: INC ENGINEERING  
Address: 333 West state street  
Phone: 808 555 6509  
Fax: 1 808 555 6509  
e-mail: colorcompany@gmail.com




No.	Description	Date
1	House WEEK 5	09/18/20

House for week #5


Yiana Tjotjos  
Assignment #13  
Section

Project number	Assignment #13
Date	Issue Date
Drawn by	Author
Checked by	Checker
<b>A303</b>	
Scale	1/4" = 1'-0"

4/17/2020 04:45:00 PM

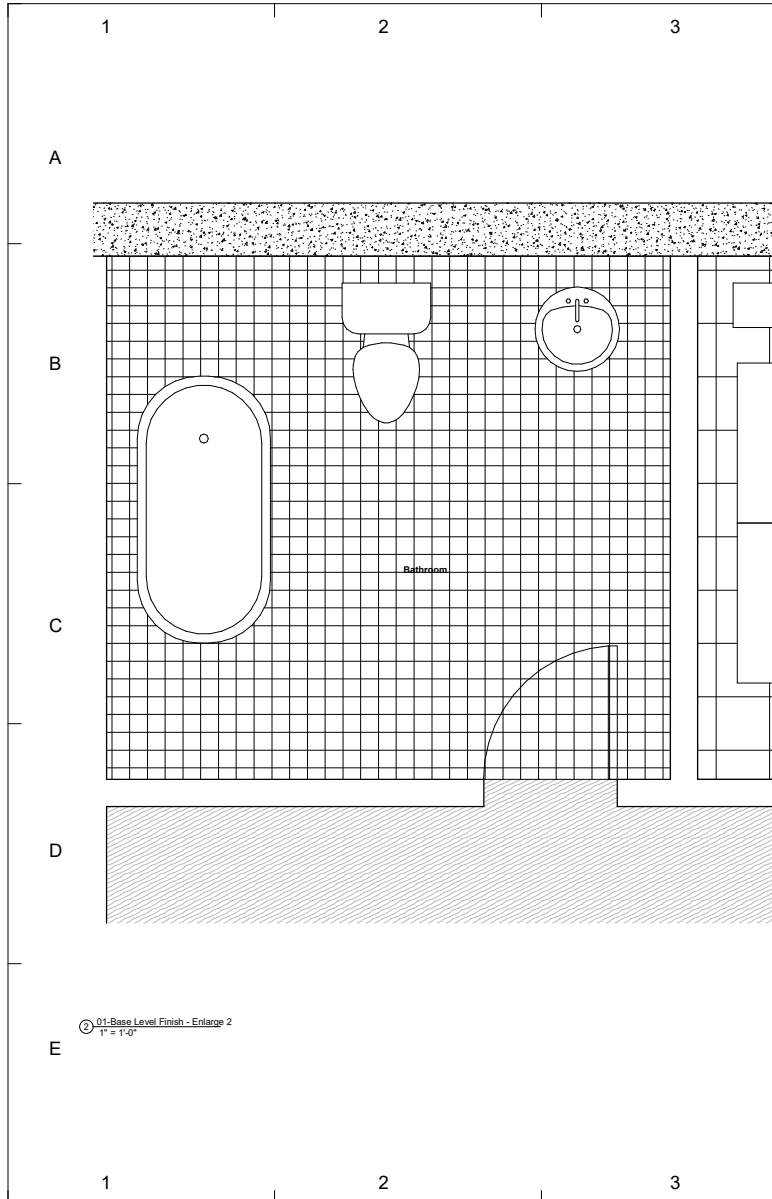

② 01-Base Level Finish - Enlarge 2  
1" = 1'-0"

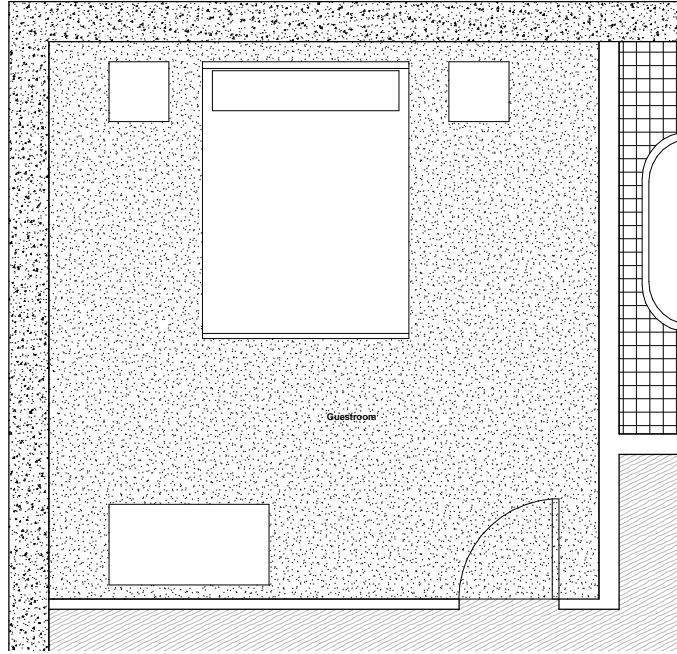

① 01-Base Level Finish - Enlarge  
3/4" = 1'-0"



www.mollygildar.com

Consultant: INC ENGINEERING  
Address: 333 West state street  
Phone: 808 555 6509  
Fax: 1 808 555 6509  
e-mail: colorcompany@gmail.com



No.	Description	Date
1	House WEEK 5	09/18/20


House for week #5

Yiana Tjotjos  
Assignment #13  
Enlarge Plans  
Basement


Project number: Assignment #13  
Date: Issue Date  
Drawn by: Molly Gildar  
Checked by: Prof. Wacta

**A401**

Scale: As indicated

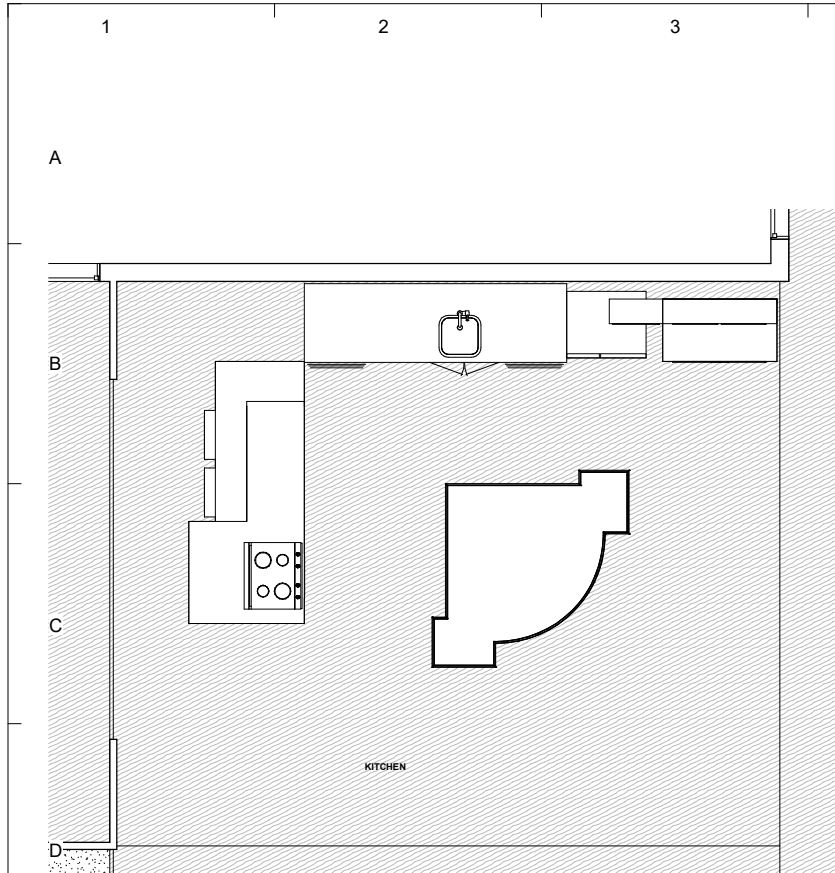

① 01-Ground Level Finish - Enlarge  
1/2" = 1'-0"

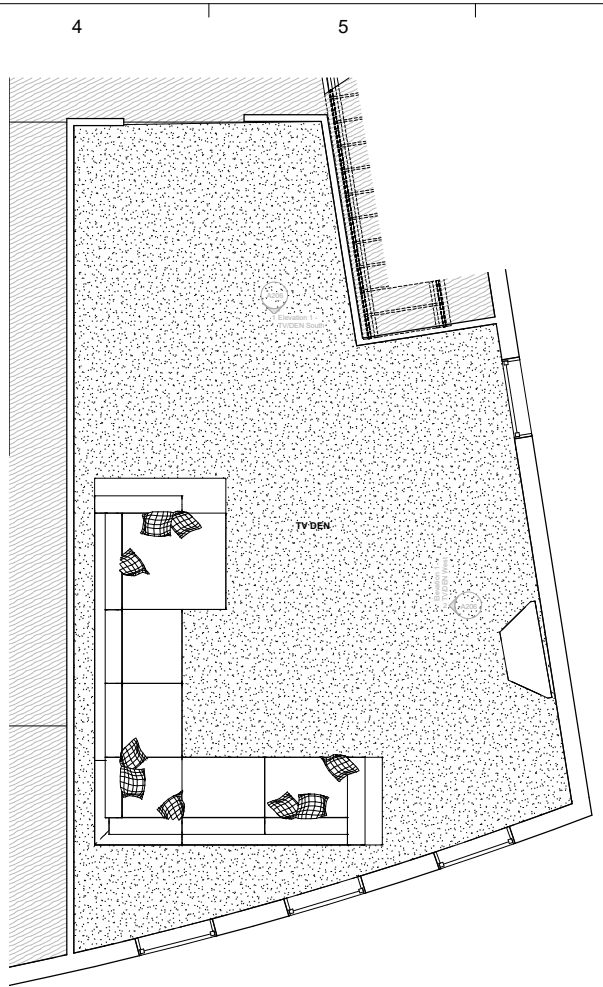


② 01-Ground Level Finish - Enlarge 1  
1/2" = 1'-0"



www.mollygildar.com

 Consultant: INC ENGINEERING  
Address: 333 West state street  
Phone: 808 555 6509  
Fax: 1 808 555 6509  
e-mail: colorcompany@gmail.com



No.	Description	Date
1	House WEEK 5	09/18/20

House for week #5


Yiana Tjotjos  
Assignment #13  
Enlarge Floor Plans  
Ground Level

Project number: Assignment #13  
Date: Issue Date  
Drawn by: Molly Gildar  
Checked by: Prof. Wacta

A402

Scale: 1/2" = 1'-0"

4/17/2020 9:45:52 PM

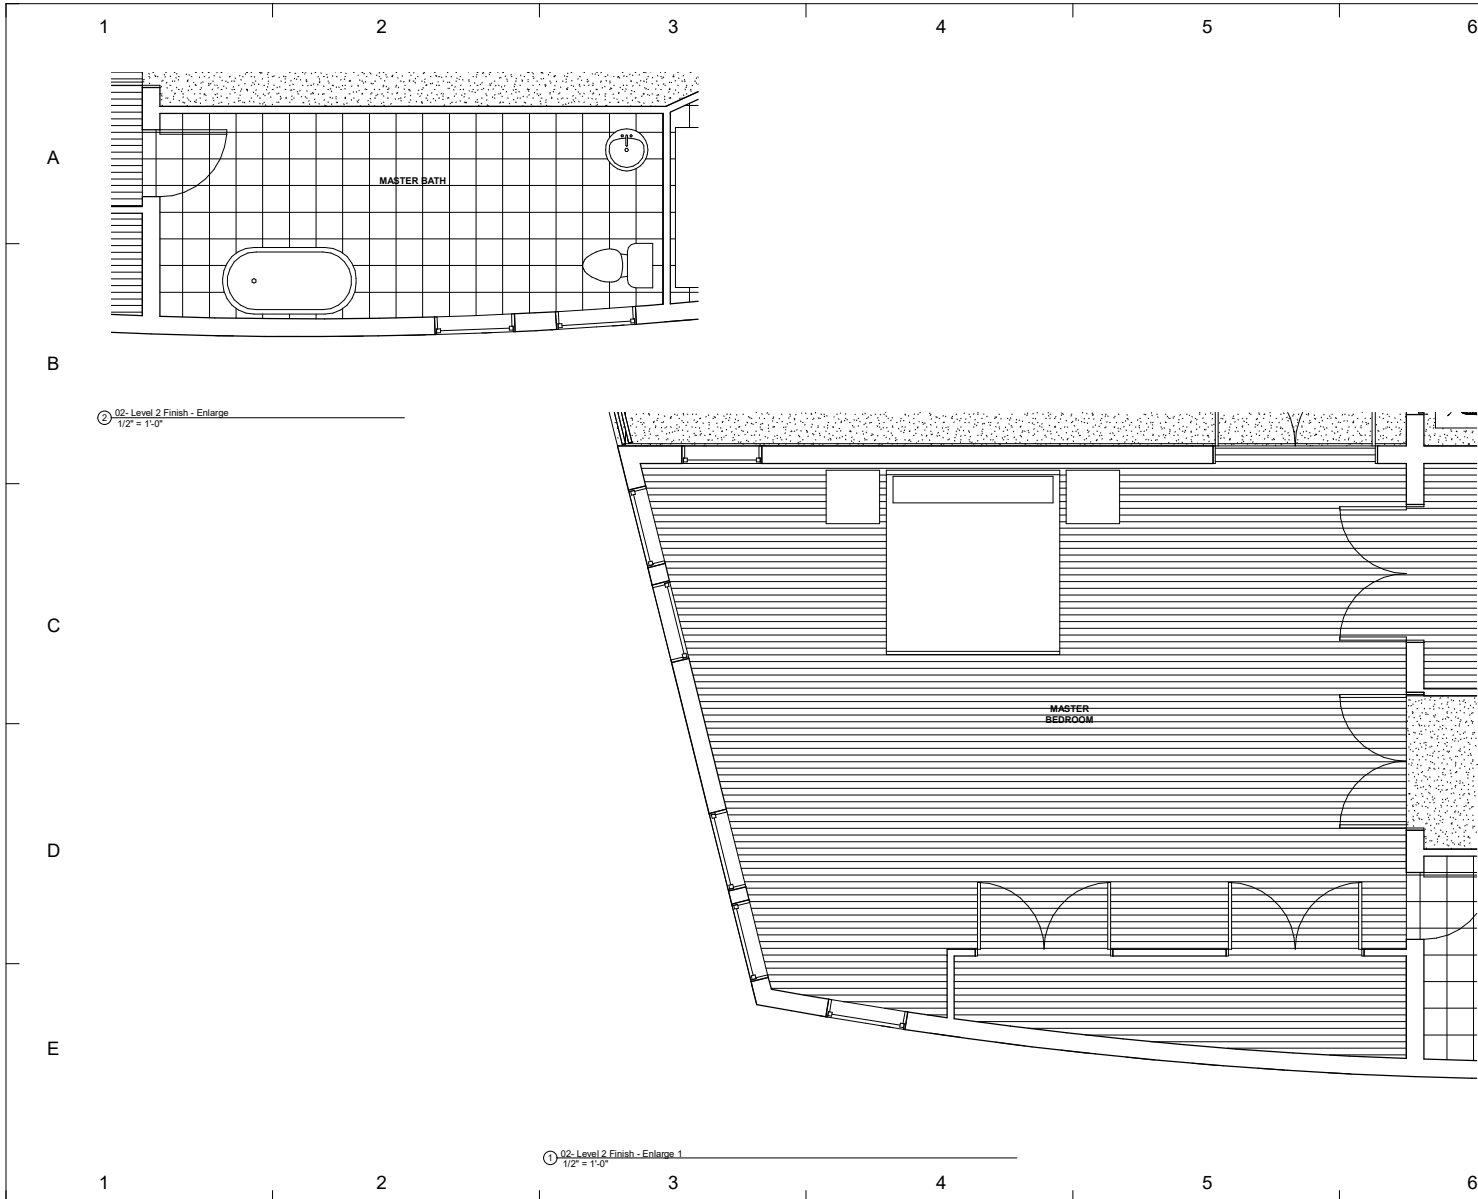

www.mollygidar.com

Consultant: INC ENGINEERING  
 Address: 333 West state street  
 Phone: 808 555 6509  
 Fax: 1 808 555 6509  
 e-mail: colorcompany@gmail.com



No.	Description	Date
1	House WEEK 5	09/18/20


House for week #5

Yiana Tjotjos  
 Assignment #13  
 Enlarged Floor Plans  
 Level 2

Project number	Assignment #13
Date	Issue Date
Drawn by	Author
Checked by	Checker

A403

Scale 1/2" = 1'-0"

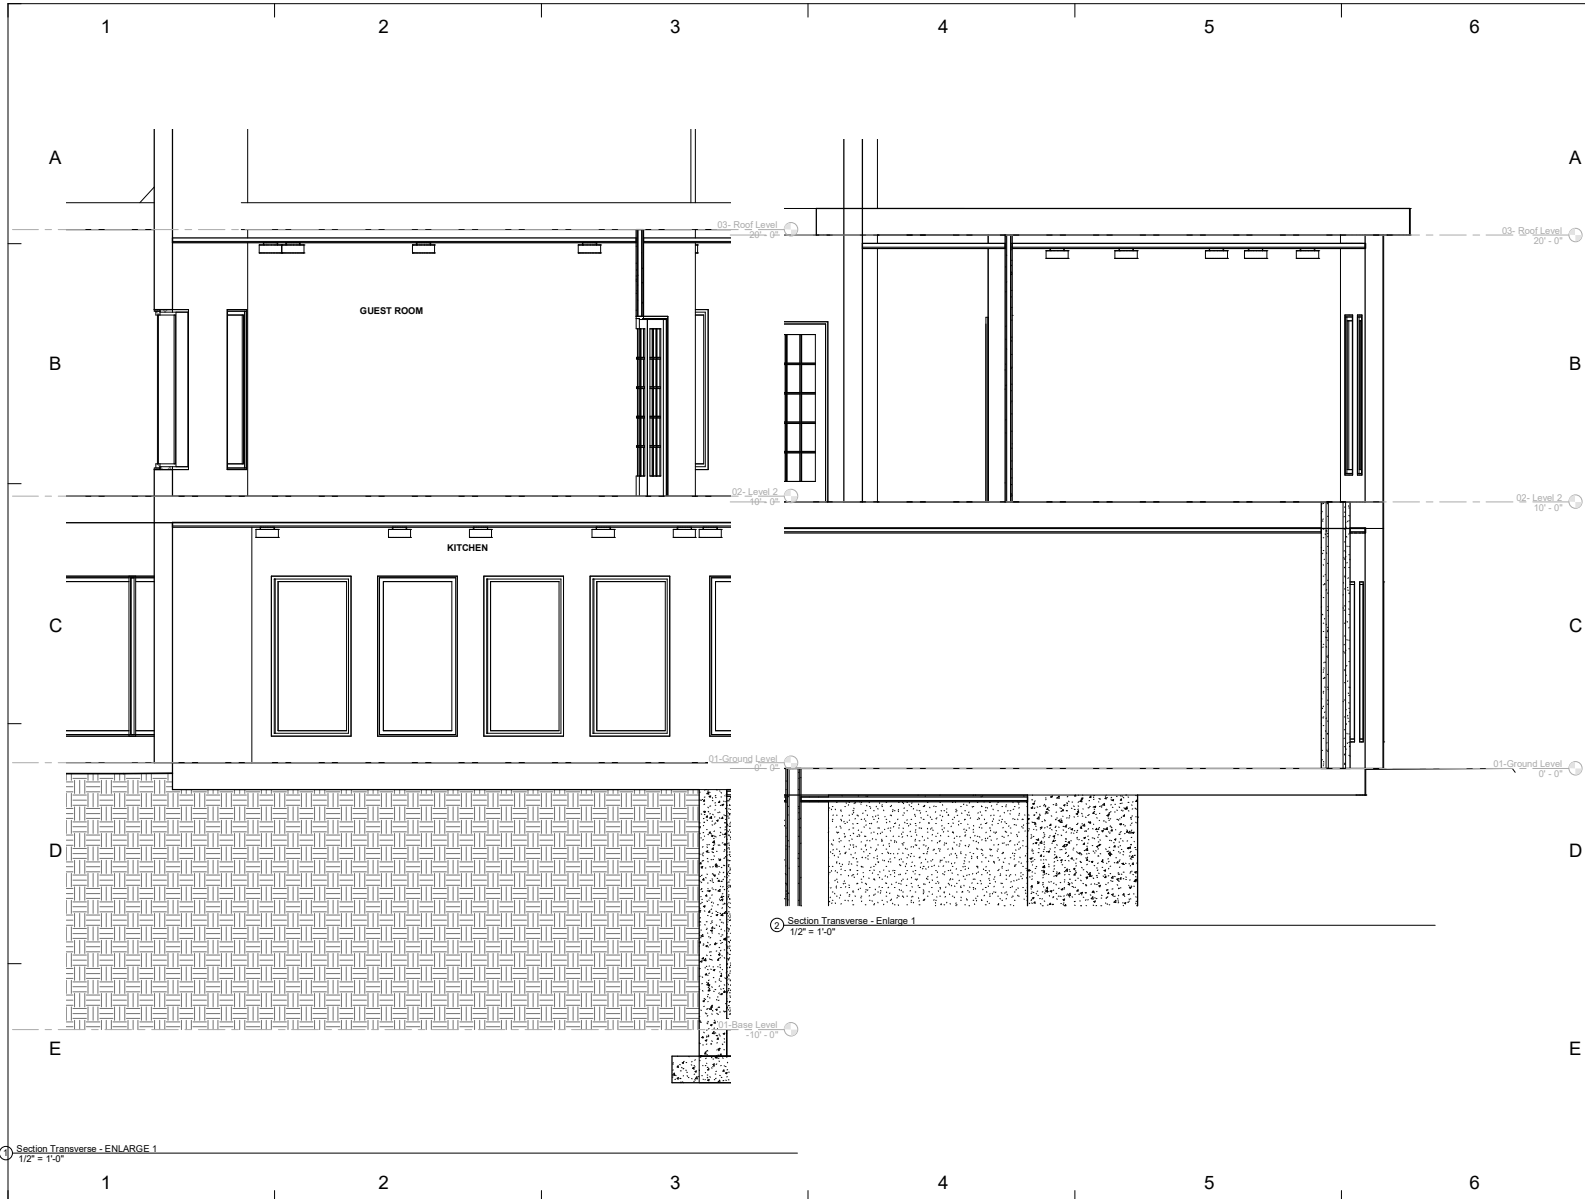

www.mollygidlar.com

Consultant: INC ENGINEERING  
 Address: 333 West state street  
 Phone: 808 555 6509  
 Fax: 1 808 555 6509  
 e-mail: colorcompany@gmail.com



No.	Description	Date
1	House WEEK 5	09/18/20

House for week #5

Yiana Tjotjos  
 Assignment #13  
 Enlarged Transverse  
 Section

Project number: Assignment #13  
 Date: Issue Date  
 Drawn by: Molly Gildar  
 Checked by: Prof. Wacta

**A404**

 
Scale: 1/2" = 1'-0"

4/17/2020 04:05:06 PM



www.mollygildar.com

Consultant: INC ENGINEERING  
 Address: 333 West state street  
 Phone: 808 555 6509  
 Fax: 1 808 555 6509  
 e-mail: colorcompany@gmail.com



No.	Description	Date
1	House WEEK 5	09/18/20

House for week #5


Yiana Tjoṭjos  
 Assignment #13  
 Enlarges Longitude  
 Section


Project number: Assignment #13  
 Date: Issue Date  
 Drawn by: Molly Gildar  
 Checked by: Prof. Wacta


**A405**

Scale: 1/4" = 1'-0"

4/17/2020 9:45:07 PM

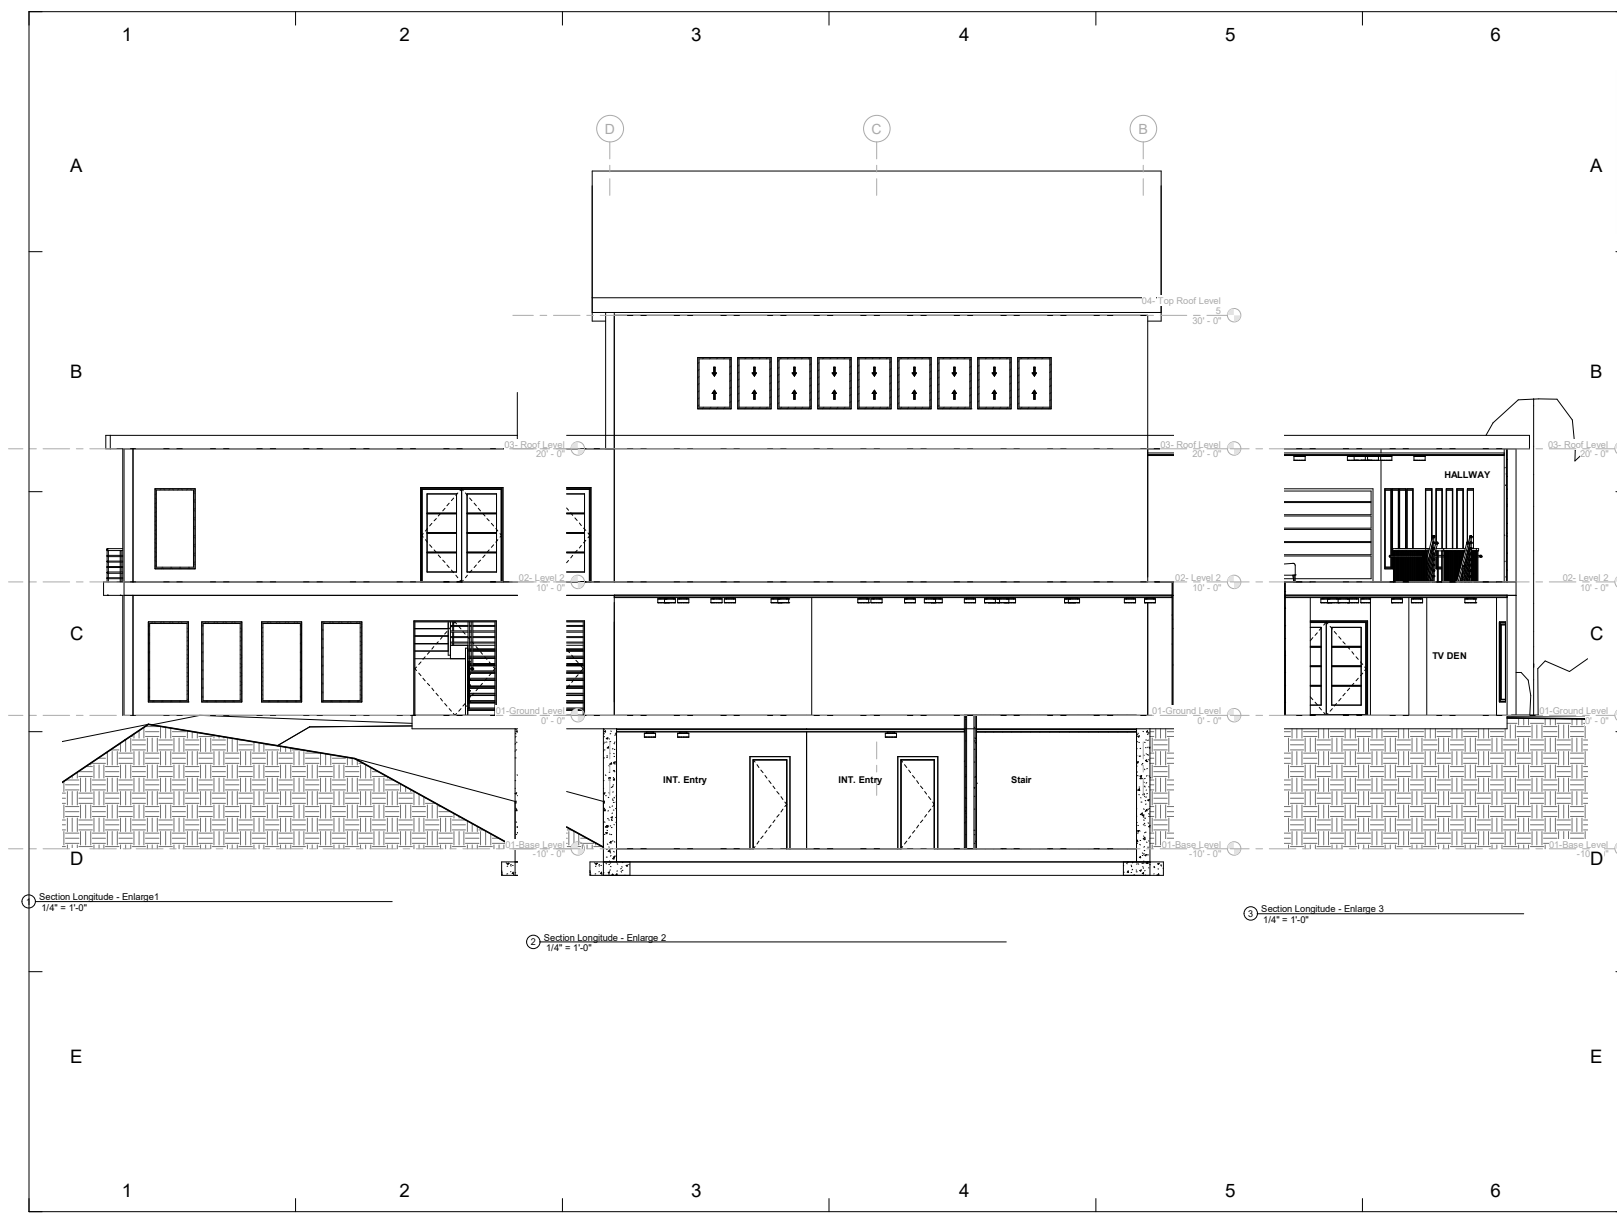

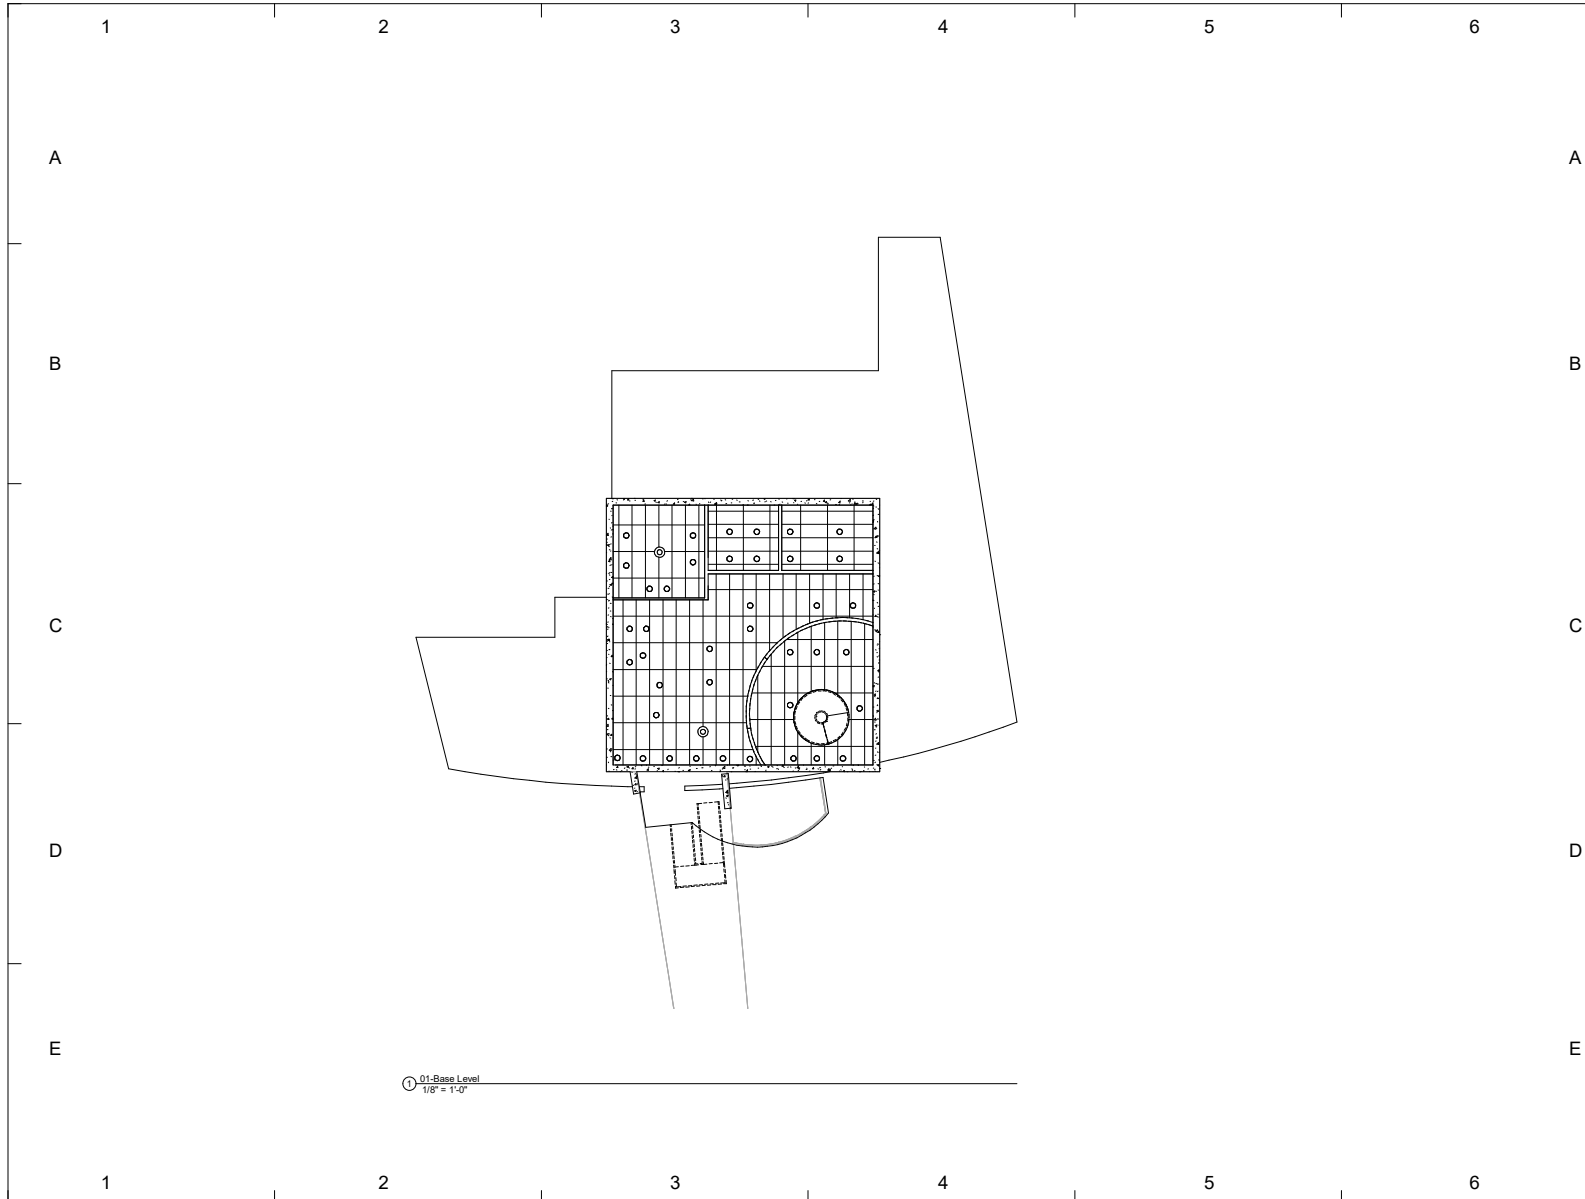




**COLOR COMPANY**

www.mollygildar.com

---

Consultant: INC ENGINEERING  
 Address: 333 West state street  
 Phone: 808 555 6509  
 Fax: 1 808 555 6509  
 e-mail: colorcompany@gmail.com



No.	Description	Date
1	House WEEK 5	09/18/20


**House for week #5**

**Yiana Tjotjos**

**Assignment #13**


**Ceiling Plan Basement**

Project number	Assignment #13
Date	Issue Date
Drawn by	Author
Checked by	Checker
<b>A501</b>	
Scale	1/8" = 1'-0"

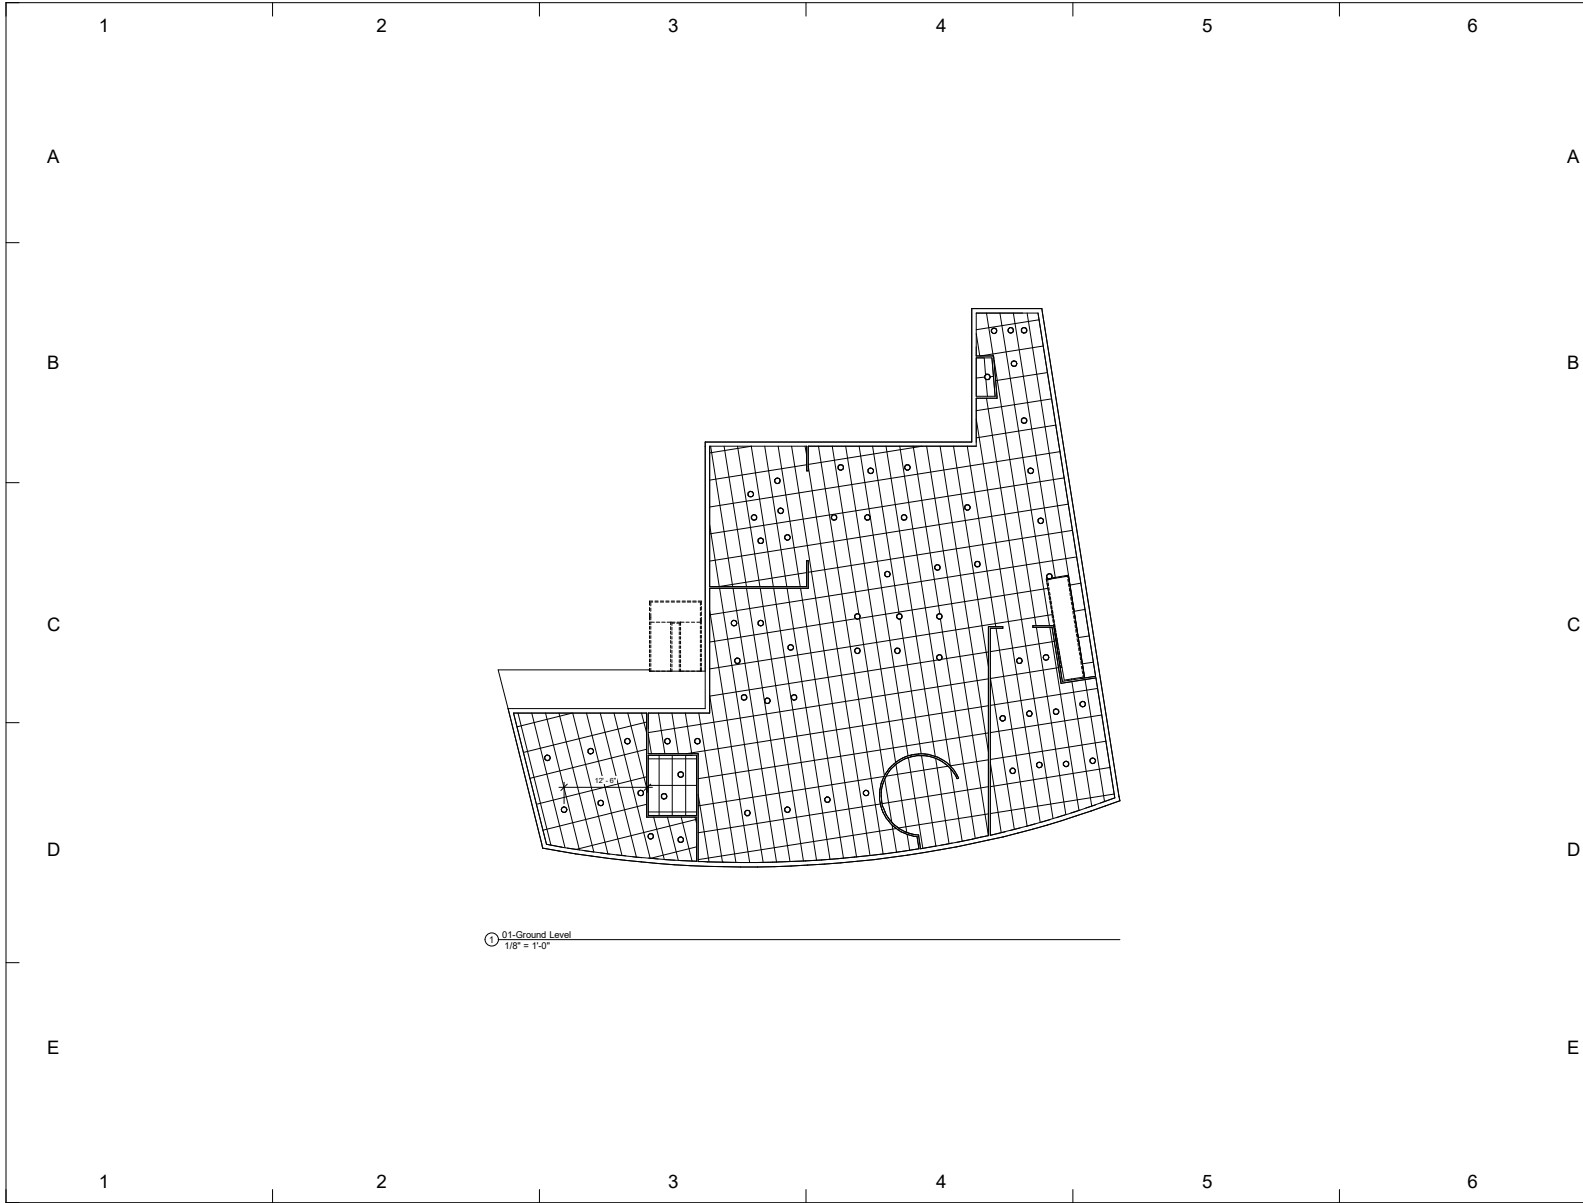

www.mollygildar.com

 Consultant: INC ENGINEERING  
 Address: 333 West state street  
 Phone: 808 555 6509  
 Fax: 1 808 555 6509  
 e-mail: colorcompany@gmail.com




No.	Description	Date
1	House WEEK 5	09/18/20

House for week #5

Yiana Tjotjos  
 Assignment #13  
 Ceiling Plan Ground Level

Project number	Assignment #13
Date	Issue Date
Drawn by	Author
Checked by	Checker
<b>A502</b>	
Scale	1/8" = 1'-0"



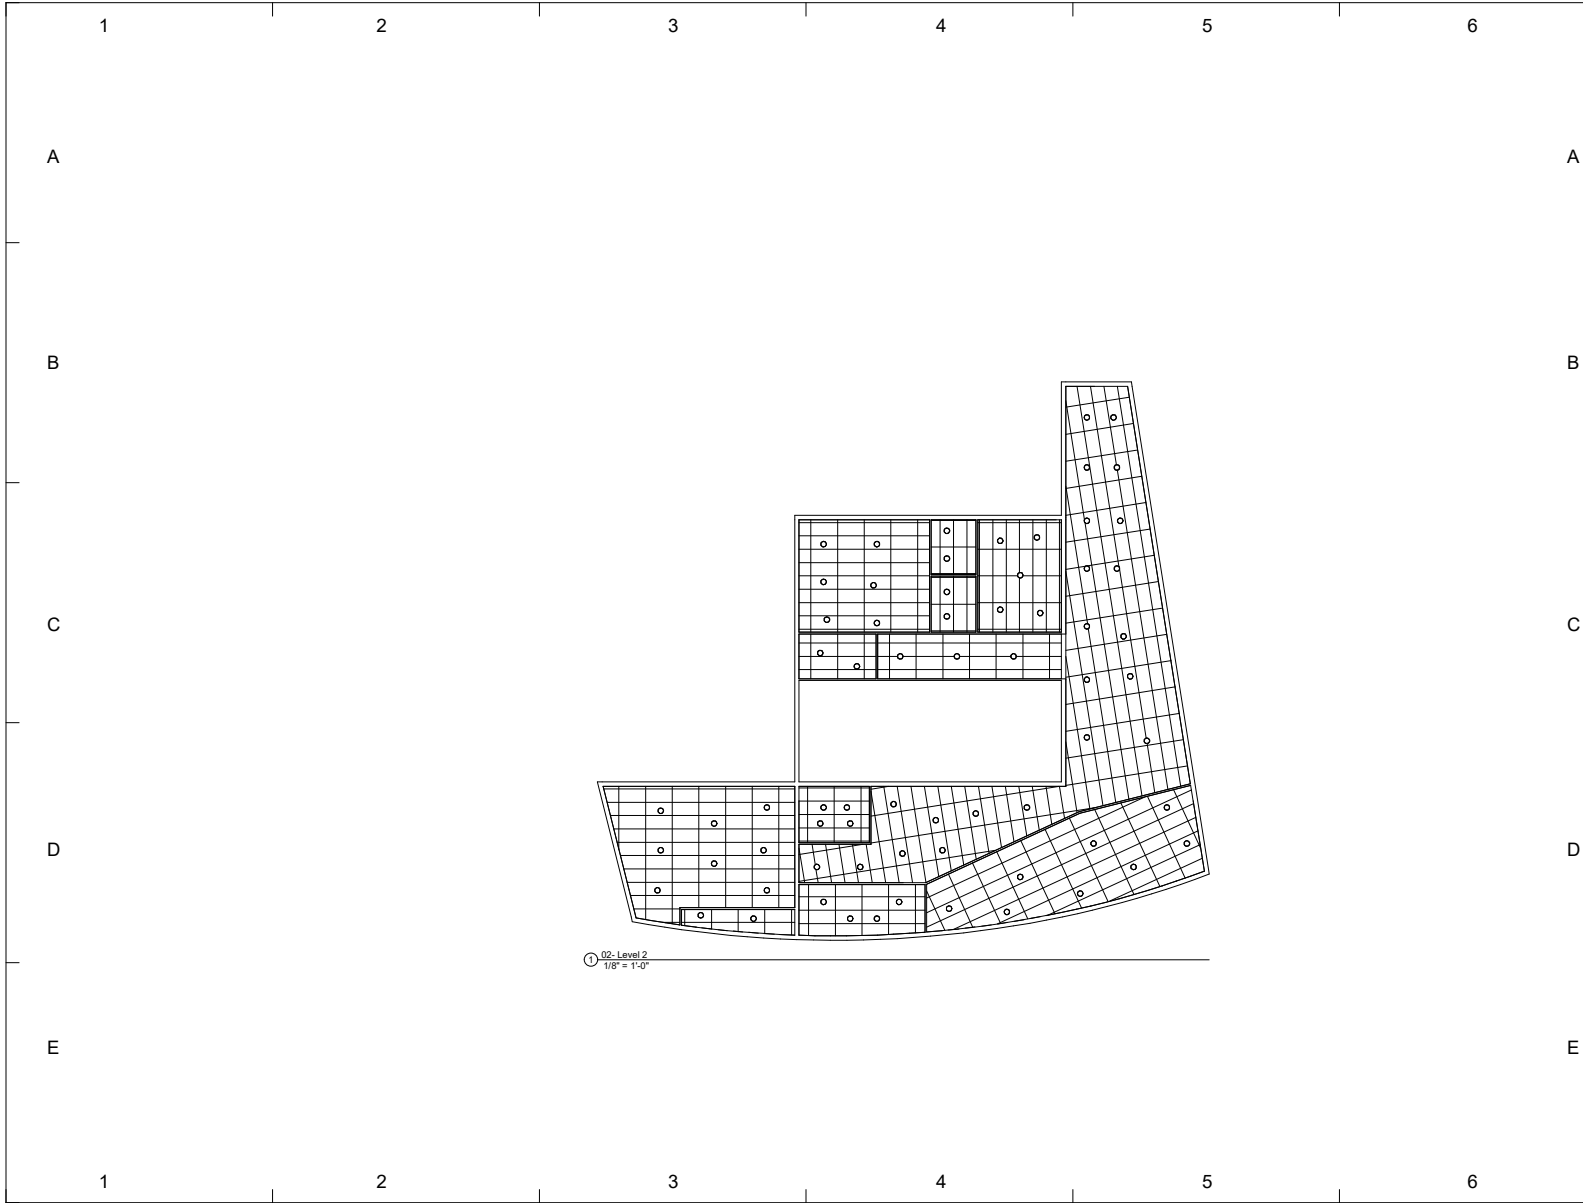


① 02- Level 2  
1/8" = 1'-0"



www.molygildar.com

 Consultant: INC ENGINEERING  
Address: 333 West state street  
Phone: 808 555 6509  
Fax: 1 808 555 6509  
e-mail: colorcompany@gmail.com



No.	Description	Date
1	House WEEK 5	09/18/20

House for week #5

Yiana Tjotjos  
Assignment #13  
Ceiling Plan Level 2

Project number	Assignment #13
Date	Issue Date
Drawn by	Author
Checked by	Checker
<b>A503</b>	
Scale	1/8" = 1'-0"

1

2

3

4

5

6

A

A



www.mollygidar.com

Consultant: INC ENGINEERING  
 Address: 333 West state street  
 Phone: 808 555 6509  
 Fax: 1 808 555 6509  
 e-mail: colorcompany@gmail.com


B

B

Door Schedule									
Level	Family and Type	Family	Height	Width	Mark	Head Height	Sill Height	Thickness	Count
01-Base Level	Door-Passage-Single-Visor_Lite 36" x 80"	Door-Passage-Single-Visor_Lite	6' - 8"	3' - 0"	2	6' - 8"	0' - 0"	0' - 1 3/4"	1
01-Base Level	Single-Flush h: 30" x 80"	Single-Flush	6' - 8"	2' - 6"		6' - 8"	0' - 0"	0' - 2"	3
01-Ground Level	Door-Exterior-Double-Full Glass-Wood_Clad: 72" x 84"	Door-Exterior-Double-Full Glass-Wood_Clad	7' - 0"	6' - 0"		7' - 0"	0' - 0"	0' - 1 3/8"	3
01-Ground Level	Door-Interior-Double-Full Glass-Wood: 60" x 80"	Door-Interior-Double-Full Glass-Wood	6' - 8"	5' - 0"	11	6' - 8"	0' - 0"	0' - 1 3/8"	1
01-Ground Level	Single-Flush h: 30" x 80"	Single-Flush	6' - 8"	2' - 6"		6' - 8"	0' - 0"	0' - 2"	2
02-Level 2	Door-Exterior-Double-Full Glass-Wood_Clad: 72" x 84"	Door-Exterior-Double-Full Glass-Wood_Clad	7' - 0"	6' - 0"	31	7' - 0"	0' - 0"	0' - 1 3/8"	1
02-Level 2	Door-Interior-Double-Full Glass-Wood: 60" x 80"	Door-Interior-Double-Full Glass-Wood	6' - 8"	5' - 0"		6' - 8"	0' - 0"	0' - 1 3/8"	8
02-Level 2	Single-Flush h: 30" x 80"	Single-Flush	6' - 8"	2' - 6"		6' - 8"	0' - 0"	0' - 2"	5

C

C

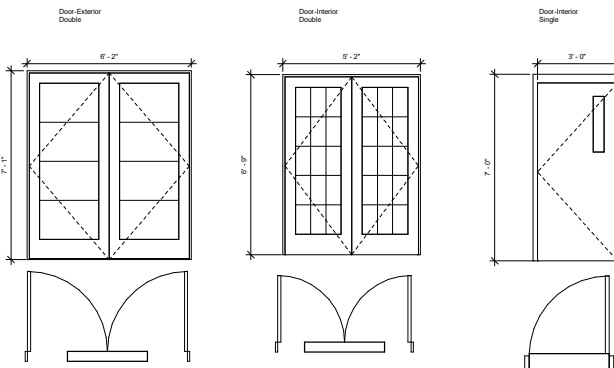

○ Door Legend  
 1/2" = 1'-0"

D

D

House for week #5

E

E

Yiana Tjotjos  
 Assignment #12  
 Door Schedule

Project number	Assignment #12
Date	Issue Date
Drawn by	Molly Gildar
Checked by	Prof. Wacta
<b>A601</b>	
Scale	1/2" = 1'-0"

1

2

3

4

5

6

4/12/2024 4:51:17 PM

1 2 3 4 5 6

A

B

C





D

E

Window Schedule								
Level	Family	Family and Type	Height	Mark	Sill Height	Type Mark	Width	Count
01-Ground Level	Fixed	Fixed: 36" x 72"	6' - 0"		1' - 0"	9	3' - 0"	32
02- Level 2	Fixed	Fixed: 36" x 72"	6' - 0"		1' - 0"	9	3' - 0"	34
03- Roof Level	Window-Double-Hung	Window-Double-Hung: 30" x 46"	3' - 10"		3' - 0"	13	2' - 6"	9

Fixed Window

 Double Window

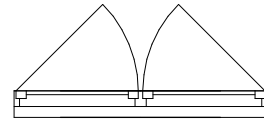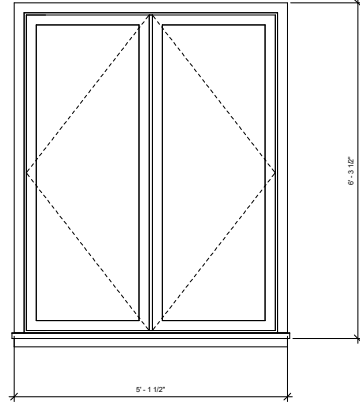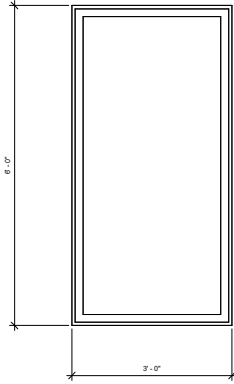

Window  
1" = 1'-0"

1 2 3 4 5 6

A

B

C

 
D

E



www.mollygildar.com

Consultant: INC ENGINEERING  
Address: 333 West state street  
Phone: 808 555 6509  
Fax: 1 808 555 6509  
e-mail: colorcompany@gmail.com



No.	Description	Date
1	House WEEK 5	09/18/20

House for week #5


Yiana Tjotjos  
Assignment #12  
Window Schedule

Project number: Assignment #12  
Date: Issue Date  
Drawn by: Molly Gildar  
Checked by: Prof. Wacta

A602

Scale: 1" = 1'-0"

4/12/2020 4:52:18 PM

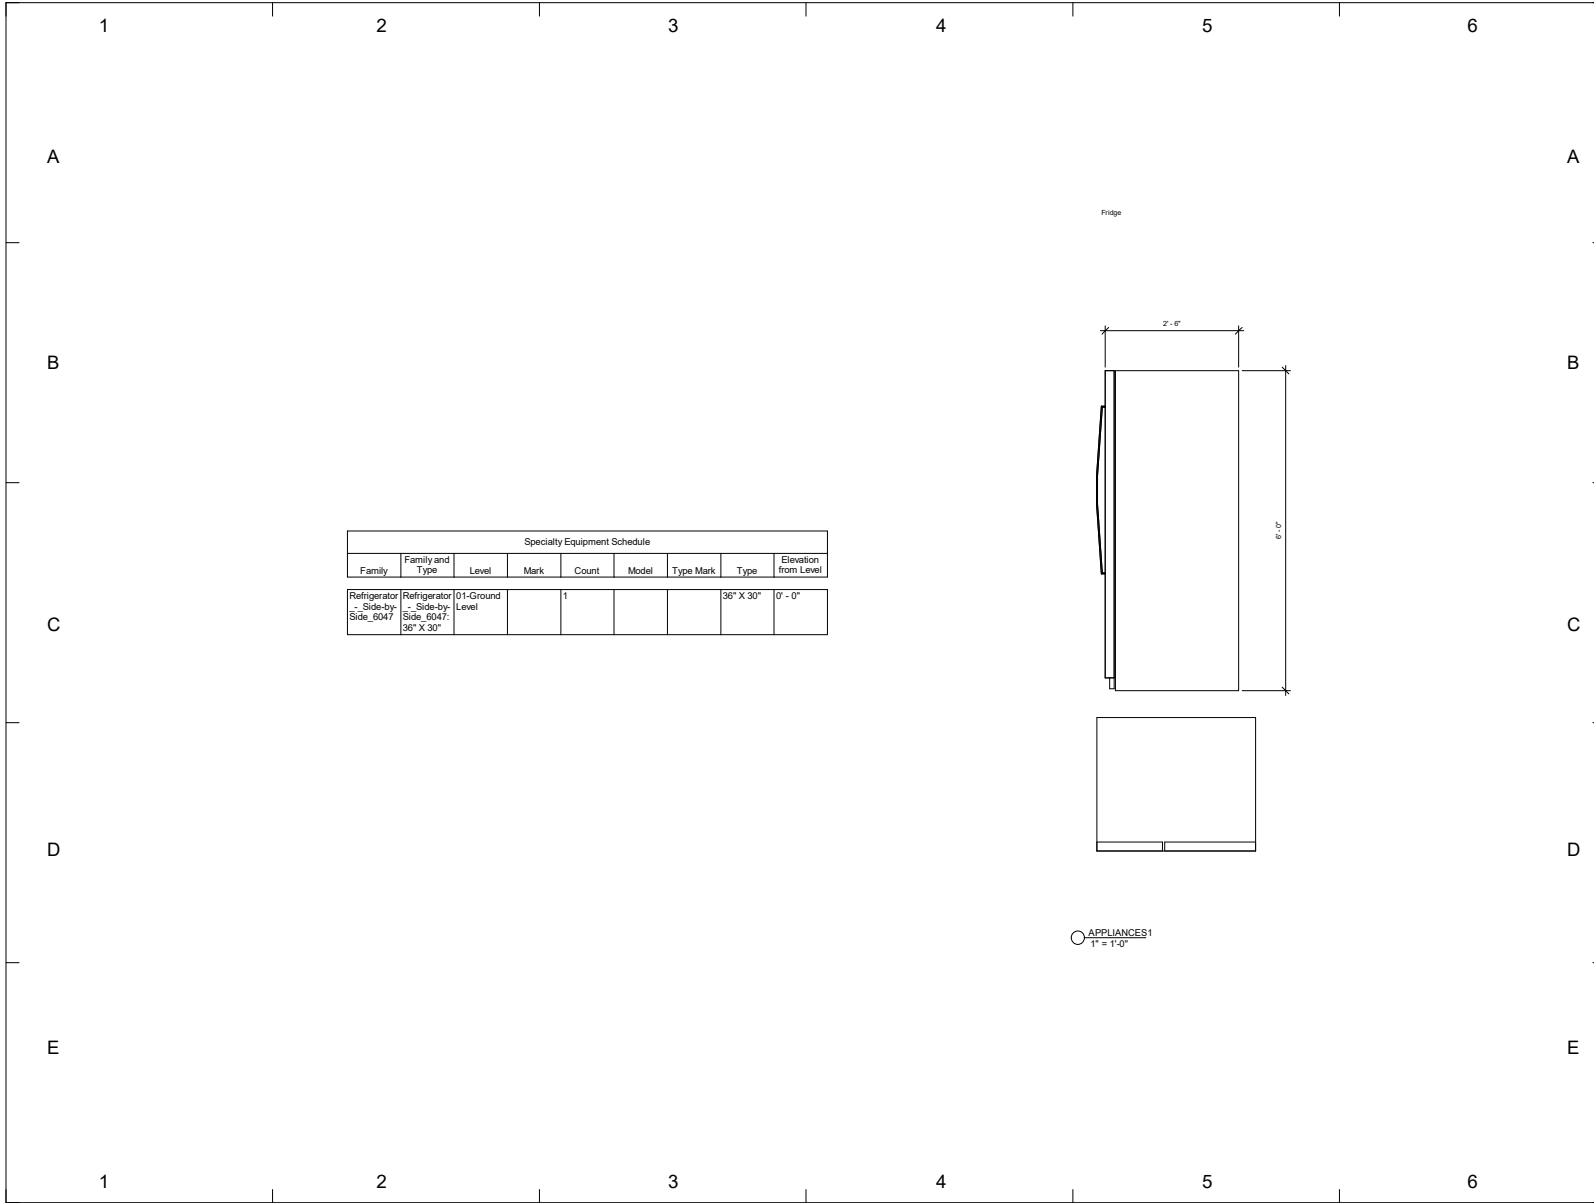


Specialty Equipment Schedule								
Family	Family and Type	Level	Mark	Count	Model	Type Mark	Type	Elevation from Level
Refrigerator	Refrigerator	01-Ground Level		1			36" X 30"	0' - 0"
Side-by-Side_5047	Side-by-Side_5047	36" X 30"						



www.mollygildar.com

 Consultant: INC ENGINEERING  
 Address: 333 West state street  
 Phone: 808 555 6509  
 Fax: 1 808 555 6509  
 e-mail: colorcompany@gmail.com



No.	Description	Date
1	House WEEK 5	09/18/20

House for week #5


**Yiana Tjotjos**  
**Assignment #12**  
**Appliance Schedule**

Project number	Assignment #12
Date	Issue Date
Drawn by	Molly Gildar
Checked by	Prof. Wacta
<b>A603</b>	
Scale	1" = 1'-0"



www.mollygidar.com

 Consultant: INC ENGINEERING  
 Address: 333 West state street  
 Address: 333 West state street  
 Phone: 808 555 6509  
 Fax: 1 808 555 6509  
 e-mail: colorcompany@gmail.com



No.	Description	Date
1	House WEEK 5	09/18/20

House for week #5

Yiana Tjotjos  
 Assignment #13  
 Light Fixture Schedule

Project number	Assignment #13
Date	Issue Date
Drawn by	Author
Checked by	Checker
<b>A604</b>	
Scale	

Lighting Fixture Schedule						
Count	Family	Family and Type	Level	Mark	Type	Type Mark
40	Ceiling Light - Flat Round	Ceiling Light - Flat Round: 60W - 120V	01-Base Level		60W - 120V	
64	Ceiling Light - Flat Round	Ceiling Light - Flat Round: 60W - 120V	01-Ground Level		60W - 120V	
68	Ceiling Light - Flat Round	Ceiling Light - Flat Round: 60W - 120V	02-Level 2		60W - 120V	
9	Ceiling Light - Flat Round	Ceiling Light - Flat Round: 60W - 120V	03- Roof Level		60W - 120V	
2	Pendant Light - Disk	Pendant Light - Disk: 100W - 277V	01-Base Level		100W - 277V	

1

2

3

4

5

6

A

B

C

D

E



① 3D View 1



② 3D View 5

1

2

3

4

5

6

A

B

C

D

E



www.molygildar.com

Consultant: INC ENGINEERING  
 Address: 333 West state street  
 Phone: 808 555 6509  
 Fax: 1 808 555 6509  
 e-mail: colorcompany@gmail.com



No.	Description	Date
1	House WEEK 5	09/18/20

House for week #5


Yiana Tjotjos  
 Assignment #13  
 3D Exterior

Project number	Assignment #13
Date	Issue Date
Drawn by	Author
Checked by	Checker
<b>A801</b>	
Scale	



www.molygildar.com

 Consultant: INC ENGINEERING  
 Address: 333 West state street  
 Phone: 808 555 6509  
 Fax: 1 808 555 6509  
 e-mail: colorcompany@gmail.com




No.	Description	Date
1	House WEEK 5	09/18/20

House for week #5


Yiana Tjoṭṭos  
 Assignment #13  
 3D Exterior 2

Project number	Assignment #13
Date	Issue Date
Drawn by	Author
Checked by	Checker
<b>A802</b>	
Scale	

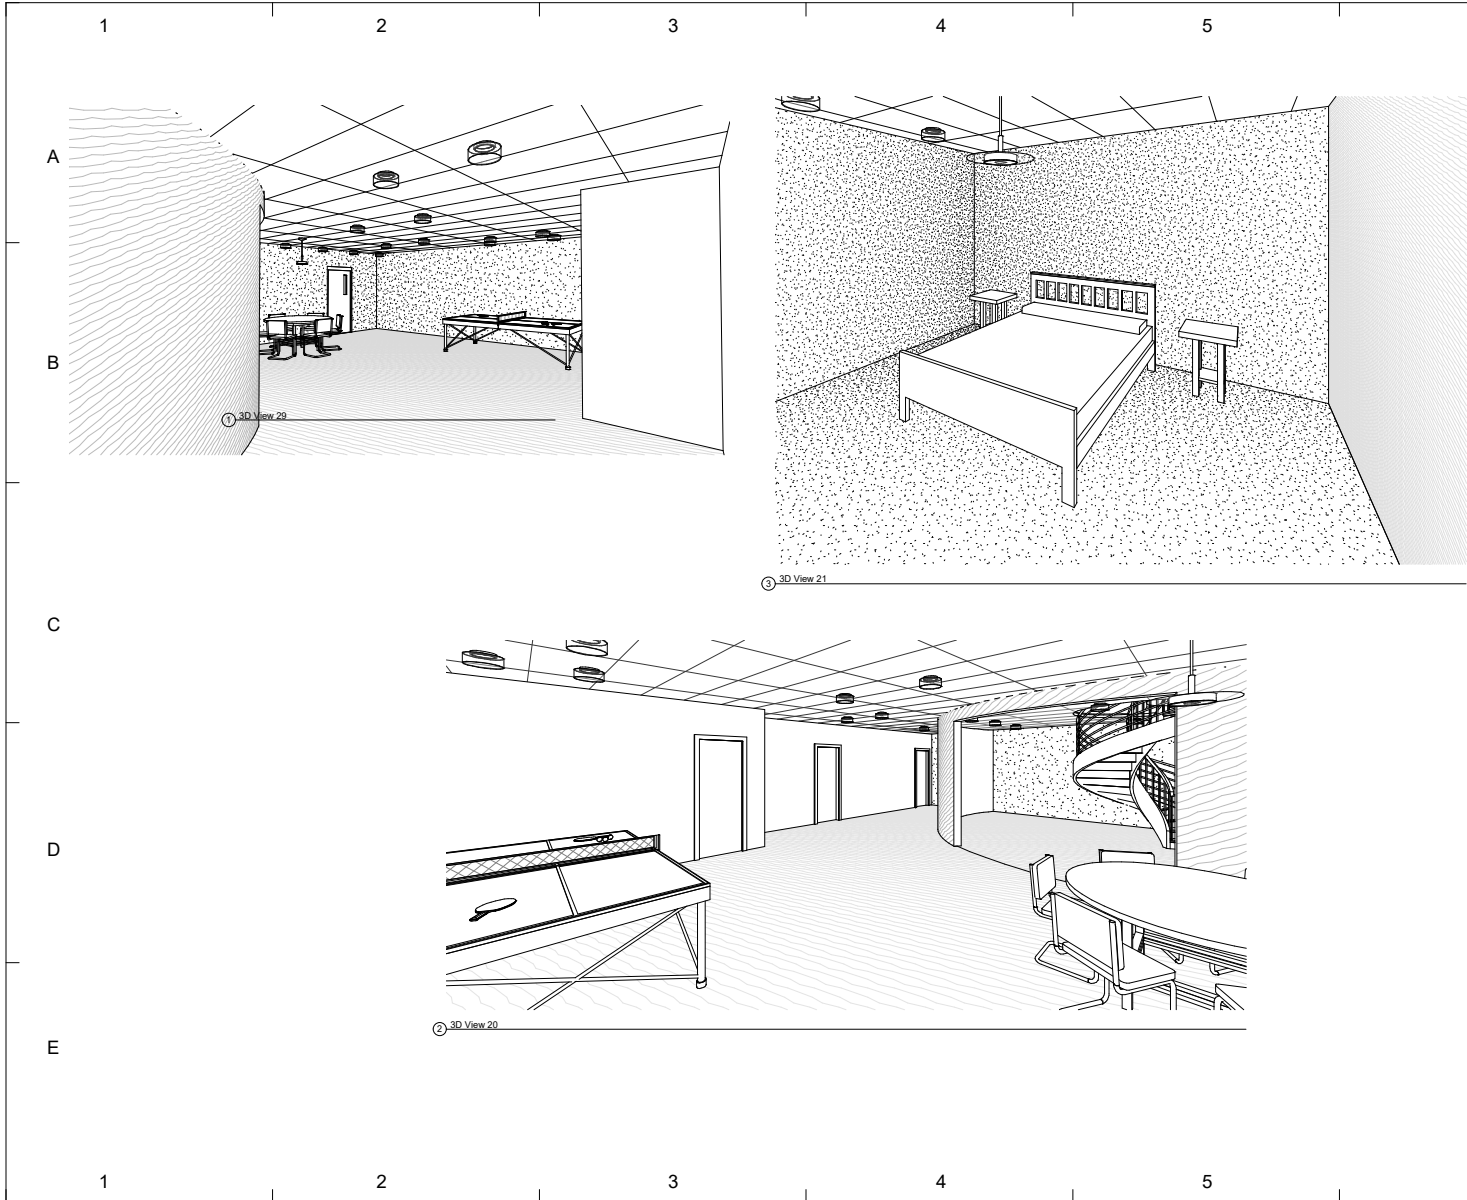

www.mollygildar.com

 Consultant: INC ENGINEERING  
 Address: 333 West state street  
 Phone: 808 555 6509  
 Fax: 1 808 555 6509  
 e-mail: colorcompany@gmail.com




No.	Description	Date
1	House WEEK 5	09/18/20

House for week #5

Yiana Tjotjos  
 Assignment #13  
 Interior Camera View  
 Base Level


Project number	Assignment #13
Date	Issue Date
Drawn by	Author
Checked by	Checker
<b>A803</b>	
Scale	



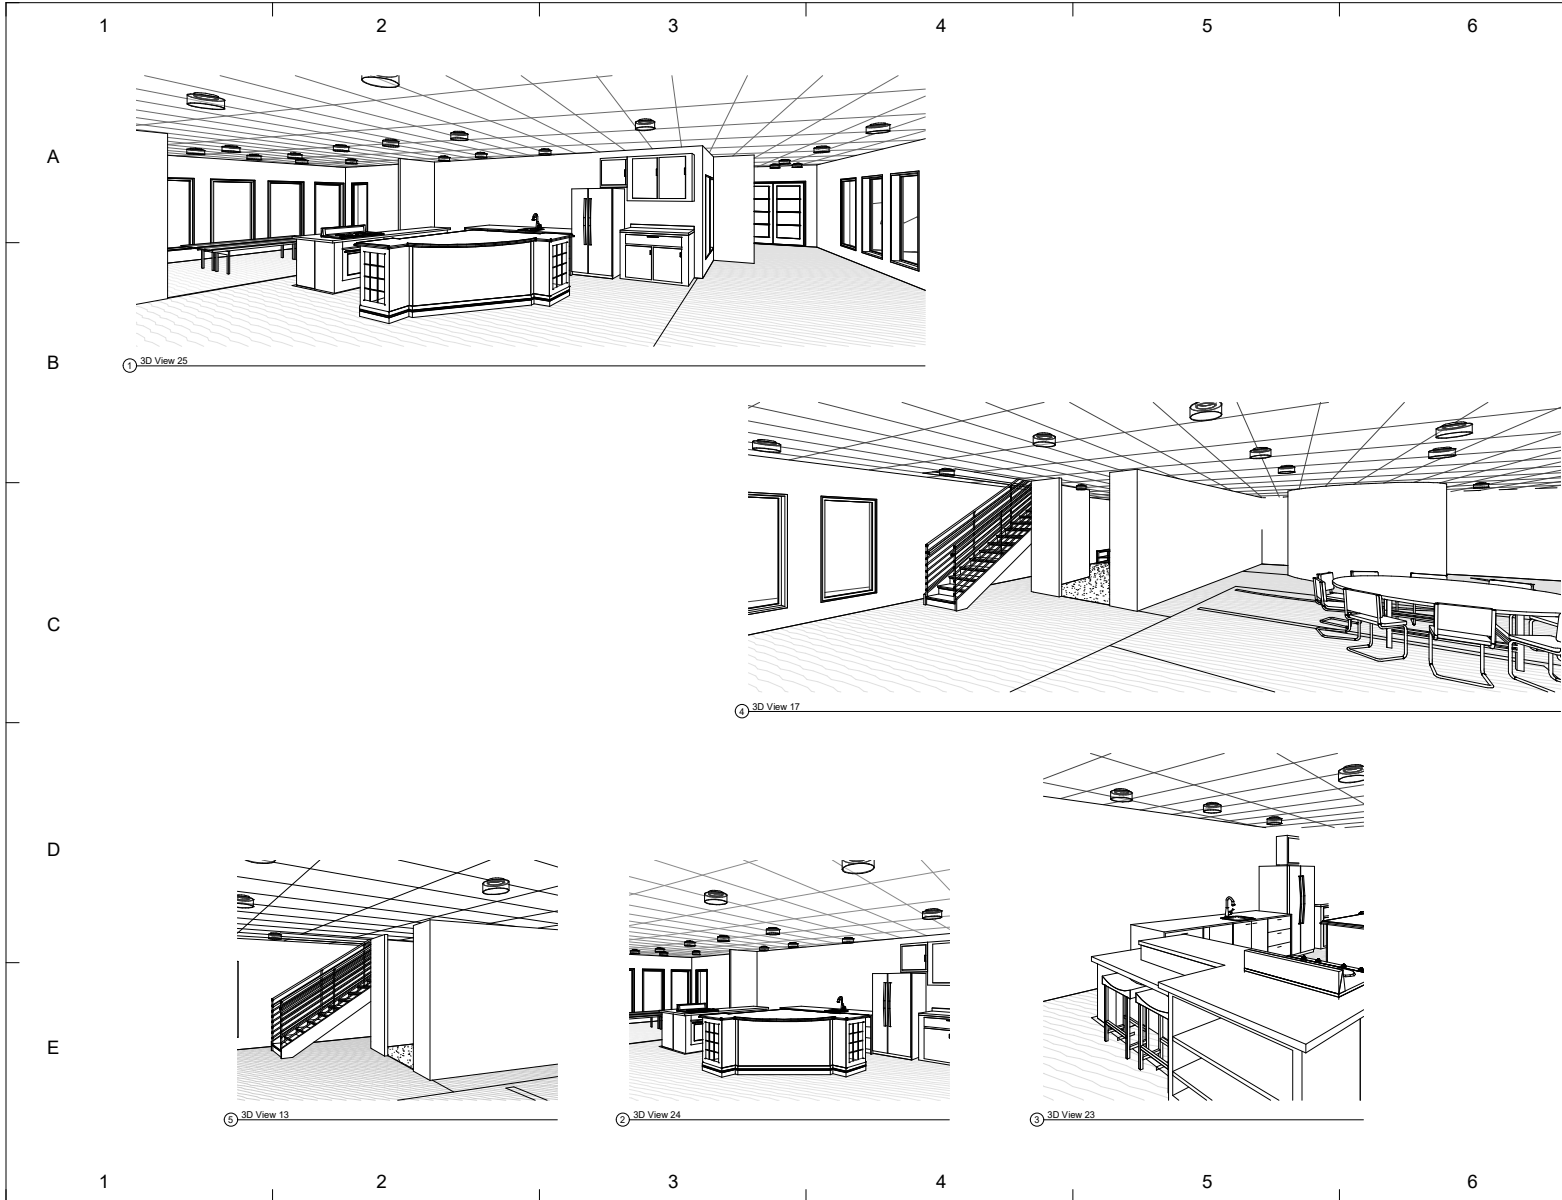

www.mollygildar.com

 Consultant: INC ENGINEERING  
 Address: 333 West state street  
 Phone: 808 555 6509  
 Fax: 1 808 555 6509  
 e-mail: colorcompany@gmail.com




No.	Description	Date
1	House WEEK 5	09/18/20

House for week #5

Yiana Tjotjos  
 Assignment #13  
 Camera View Ground Level

Project number	Assignment #13
Date	Issue Date
Drawn by	Author
Checked by	Checker
<b>A804</b>	
Scale	

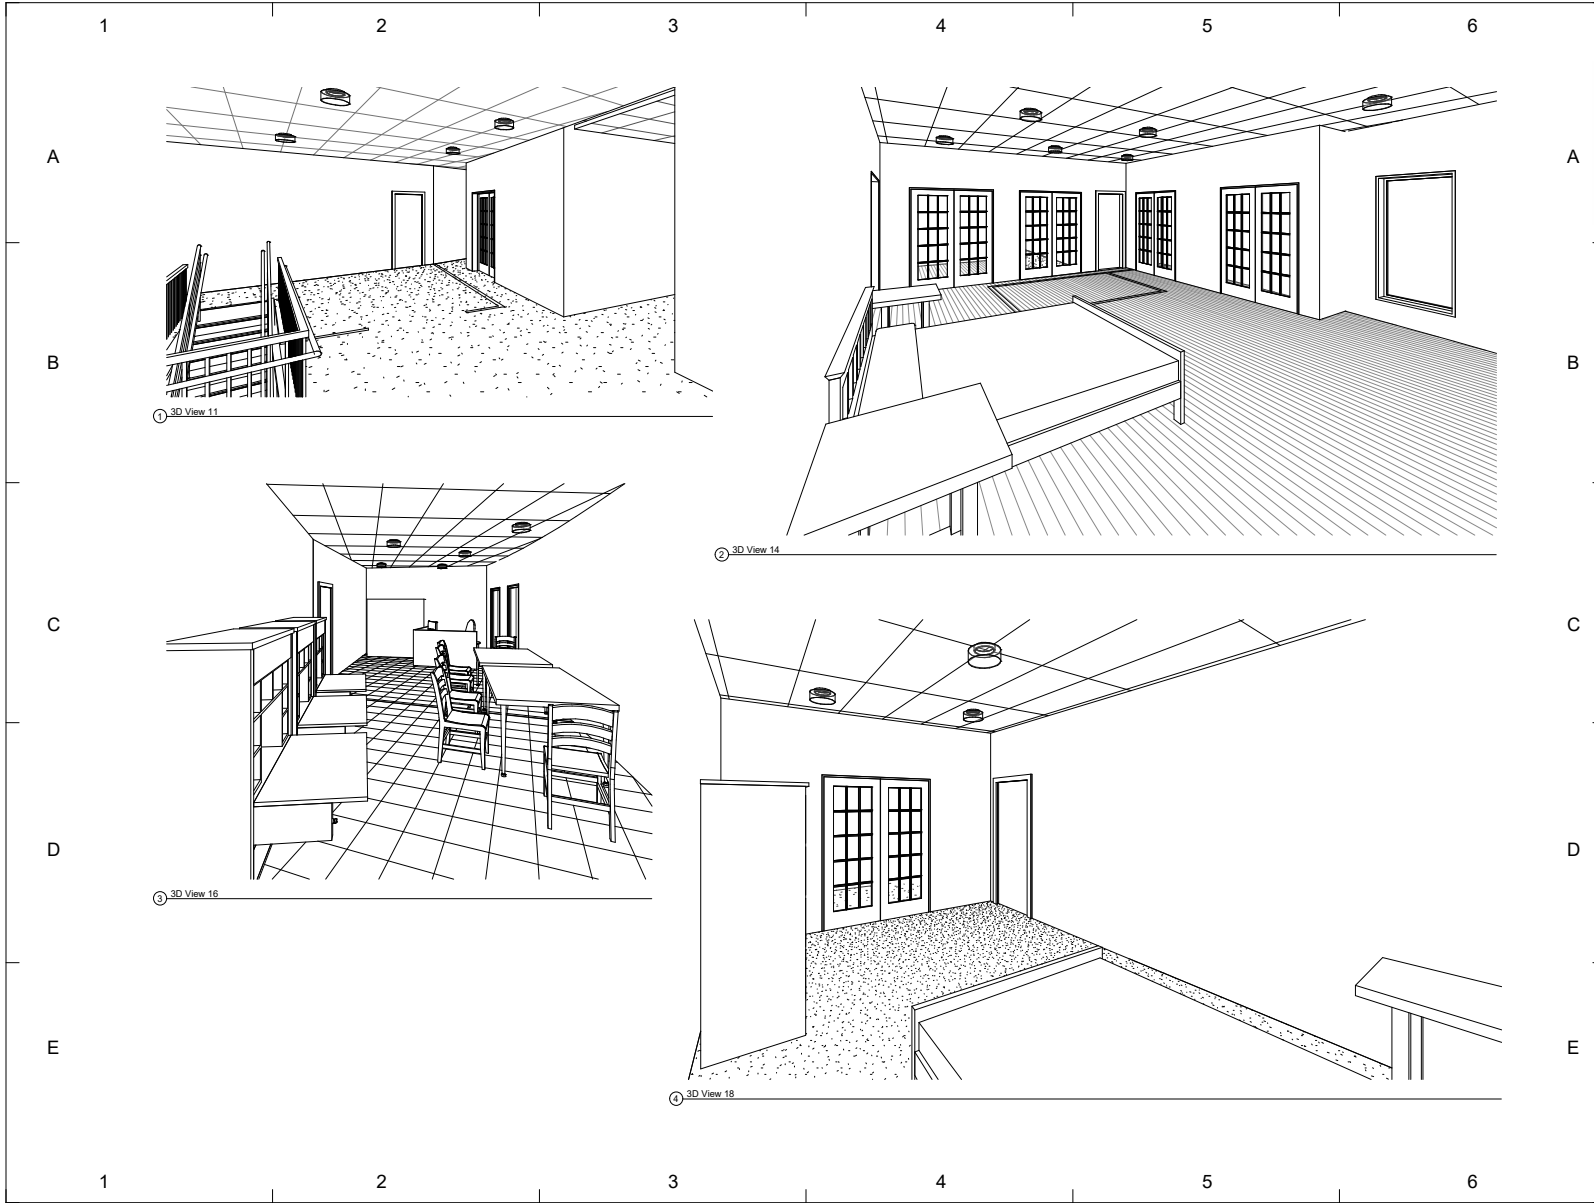


① 3D View 11

② 3D View 14

③ 3D View 16


④ 3D View 18



**COLOR COMPANY**

 www.mollygidar.com

Consultant: INC ENGINEERING  
 Address: 333 West state street  
 Phone: 808 555 6509  
 Fax: 1 808 555 6509  
 e-mail: colorcompany@gmail.com




No.	Description	Date
1	House WEEK 5	09/18/20

**House for week #5**

**Yiana Tjotjos**  
 Assignment #13  
 Interior Camera View  
 Level 2

Project number	Assignment #13
Date	Issue Date
Drawn by	Author
Checked by	Checker
<b>A805</b>	
Scale	

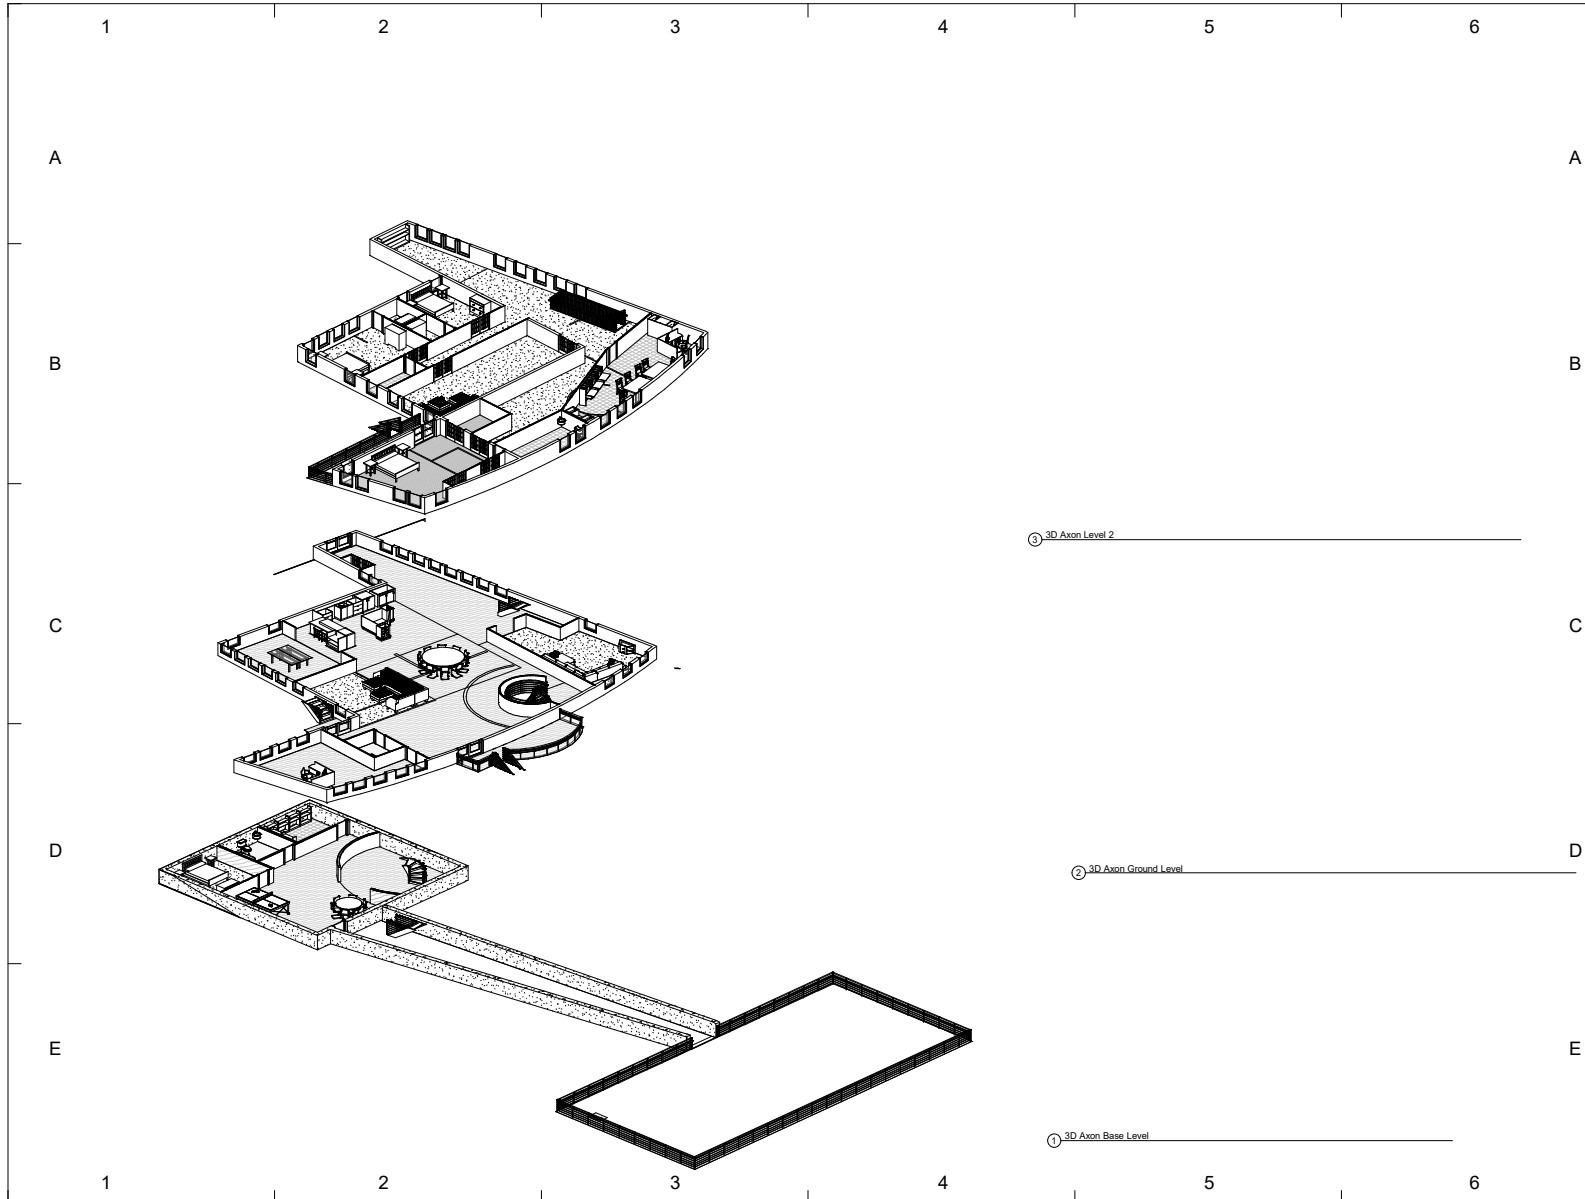

www.mollygildar.com

Consultant: INC ENGINEERING  
 Address: 333 West state street  
 Phone: 808 555 6509  
 Fax: 1 808 555 6509  
 e-mail: colorcompany@gmail.com




No.	Description	Date
1	House WEEK 5	09/18/20

House for week #5

Yiana Tjotjos  
 Assignment #13  
 Exploded Axon

Project number	Assignment #13
Date	Issue Date
Drawn by	Molly Gildar
Checked by	Prof. Wacta
<b>A901</b>	
Scale	

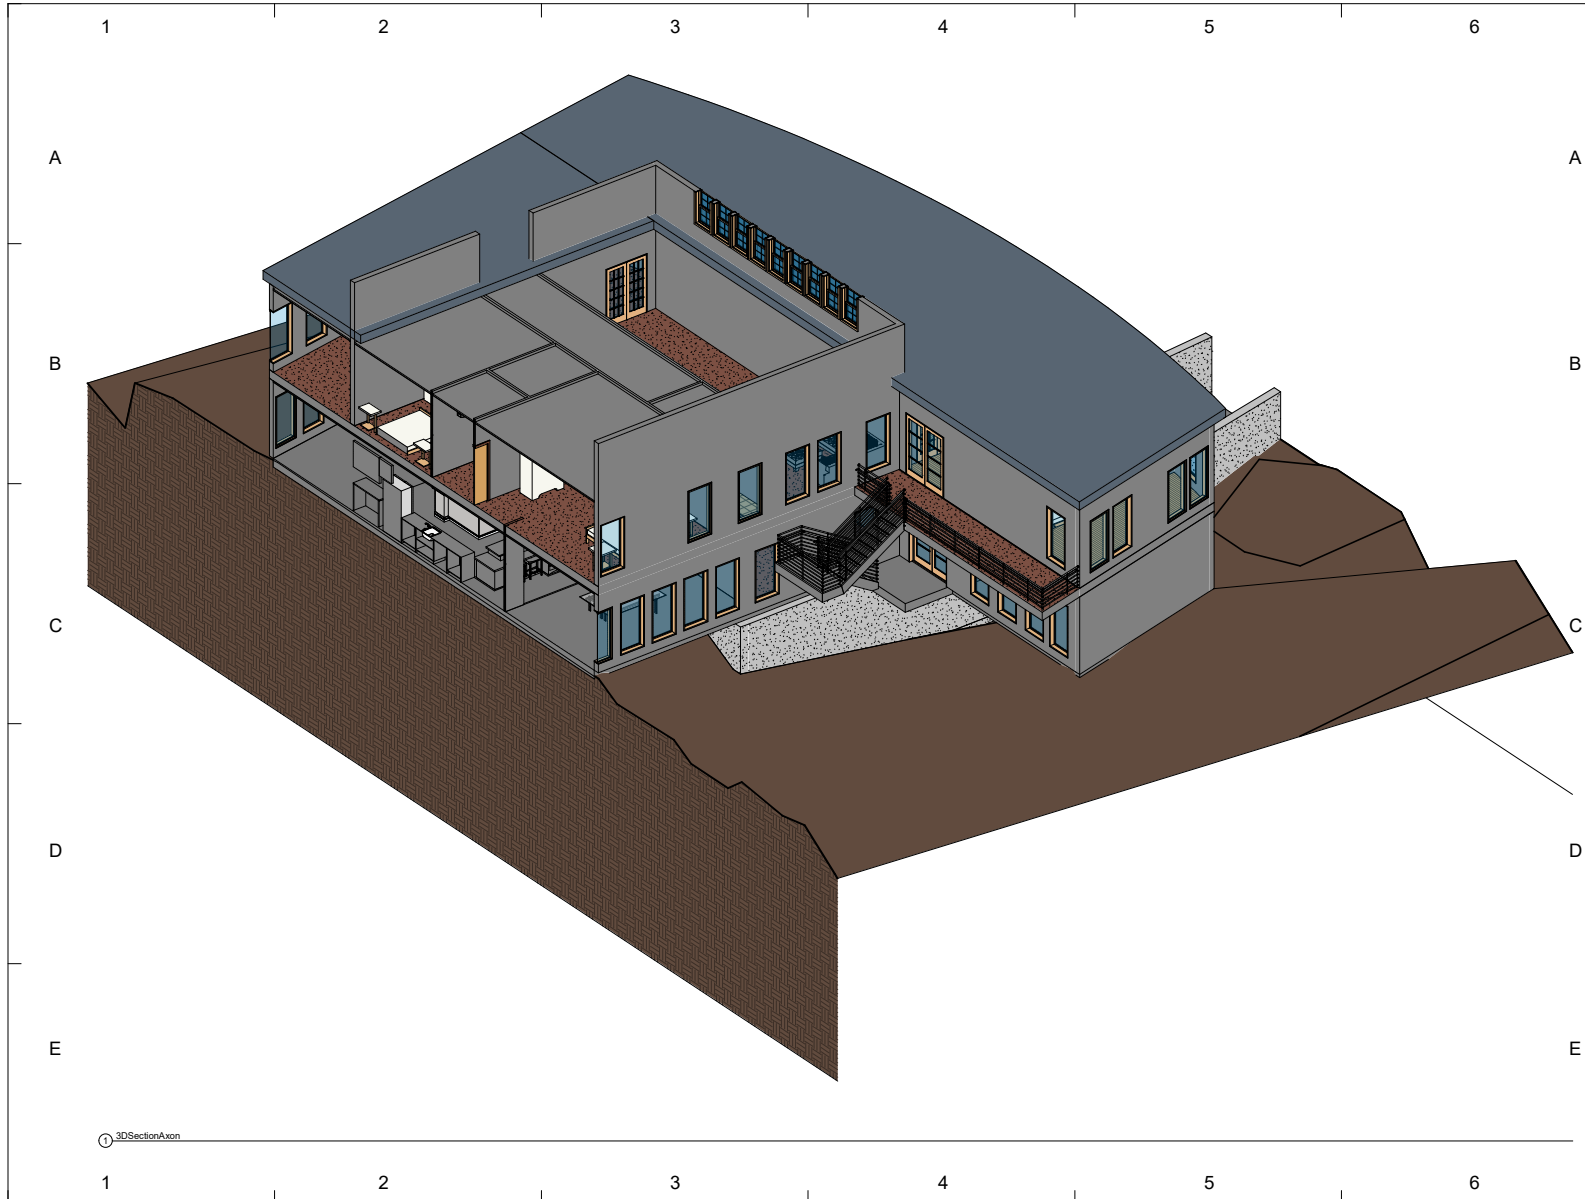

www.mollygildar.com

Consultant: INC ENGINEERING  
 Address: 333 West state street  
 Phone: 808 555 6509  
 Fax: 1 808 555 6509  
 e-mail: colorcompany@gmail.com




No.	Description	Date
1	House WEEK 5	09/18/20

House for week #5

Yiana Tjotjos  
 Assignment #13  
 Section and Axon1

Project number	Assignment #13
Date	Issue Date
Drawn by	Molly Gildar
Checked by	Prof. Wacta
<b>A902</b>	
Scale	

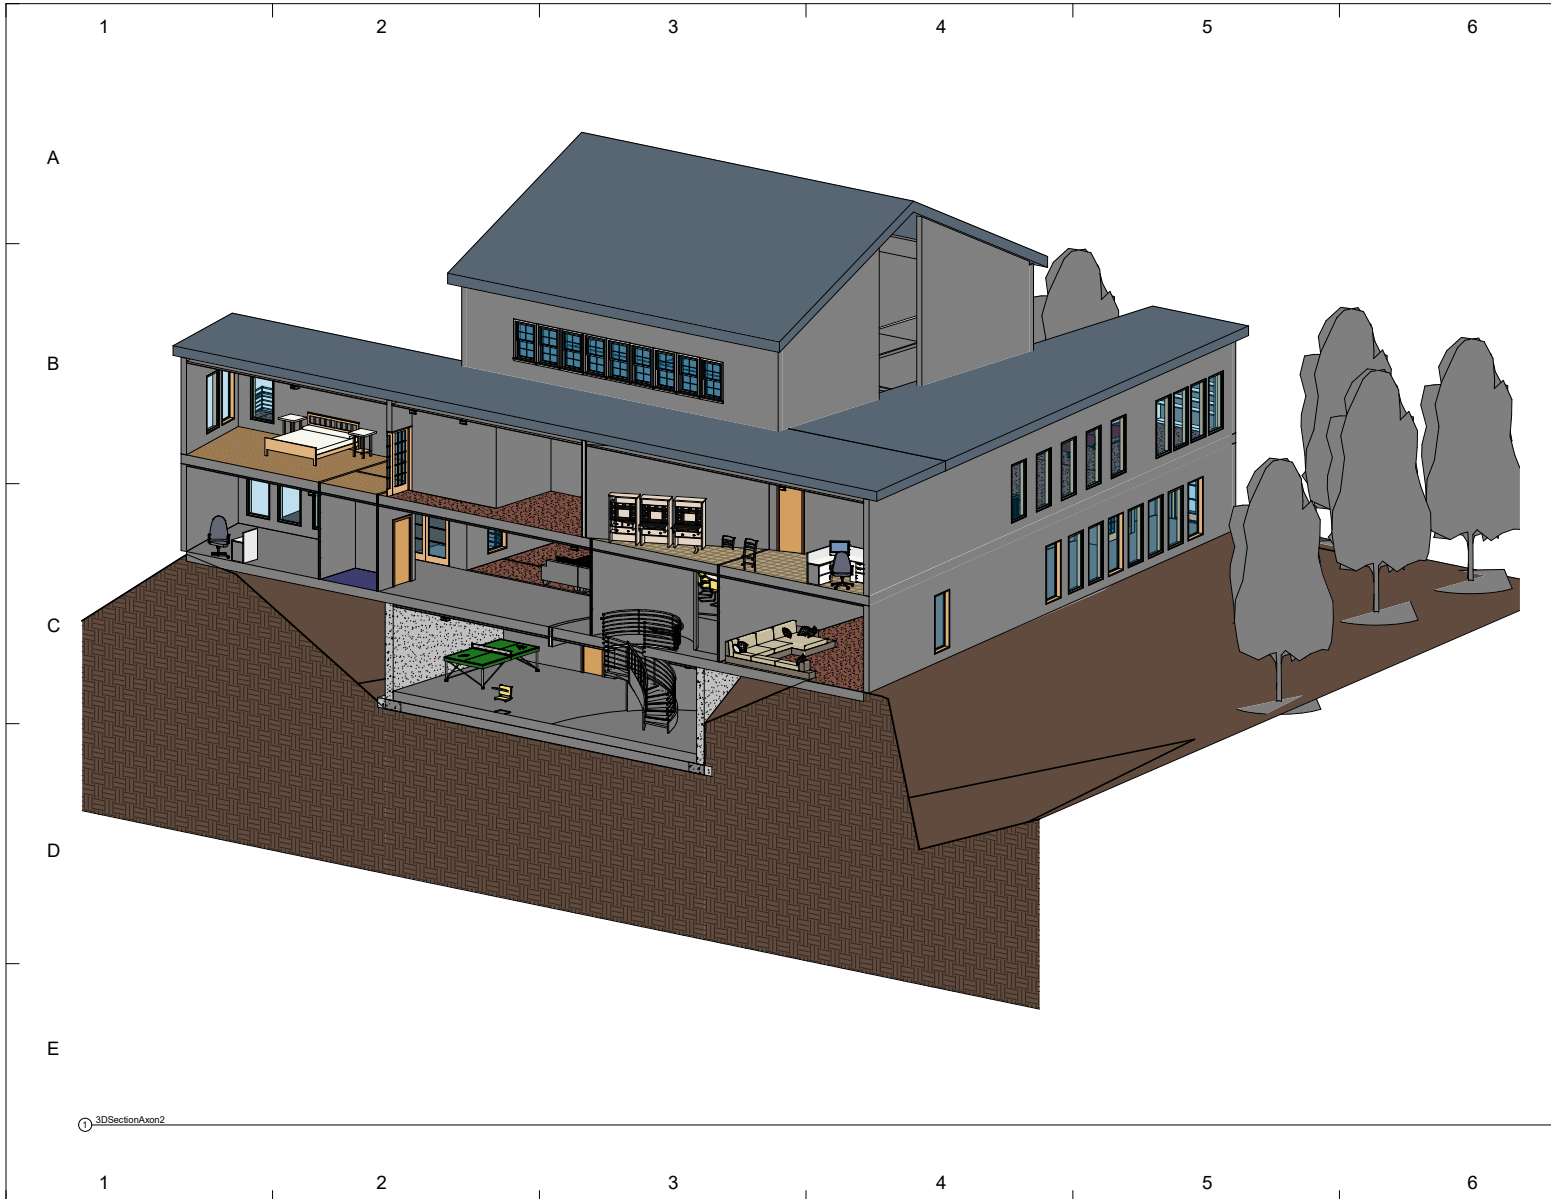

3DSectionAxon2



www.mollygidar.com

Consultant: INC ENGINEERING  
 Address: 333 West state street  
 Phone: 808 555 6509  
 Fax: 1 808 555 6509  
 e-mail: colorcompany@gmail.com



No.	Description	Date
1	House WEEK 5	09/18/20

House for week #5

Yiana Tjotjos  
 Assignment #13  
 Section and Axon

Project number	Assignment #13
Date	Issue Date
Drawn by	Molly Gildar
Checked by	Prof. Wacta
<b>A903</b>	
Scale	

4/17/2020 04:41:46 PM